


TRAVERS-SMITH RESIDENCE

119 PARK AVE | ARLINGTON, MA 02476

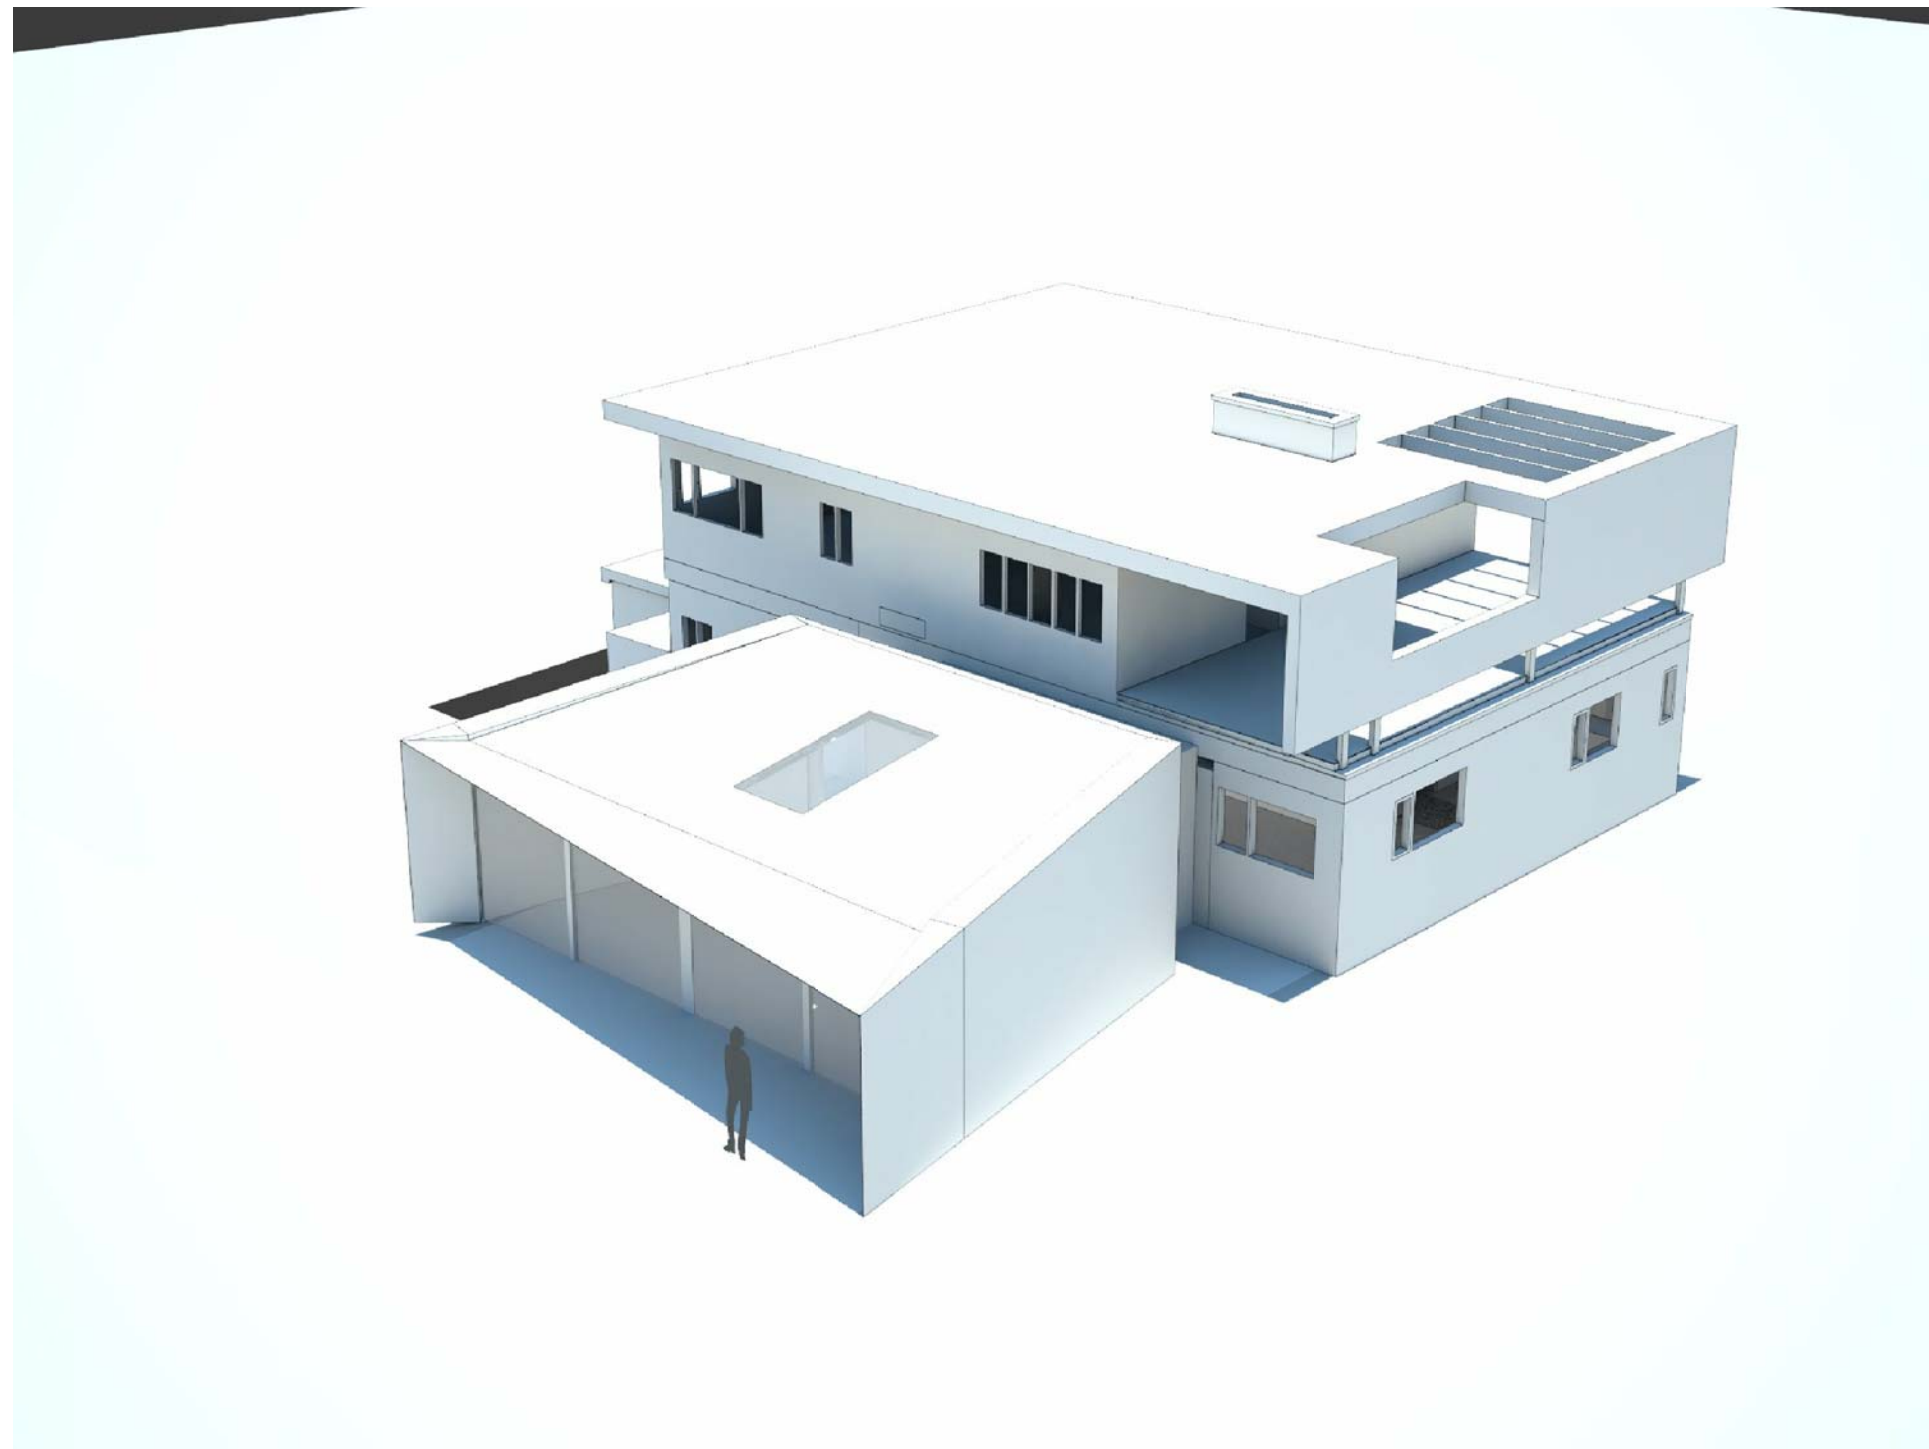

DRAWING LIST

Architectural Drawings

- A000 COVER SHEET
- D101 DEMO PLANS
- A101 BASEMENT PLAN & RCP
- A102 1ST FLOOR PLAN & RCP
- A201 EXTERIOR ELEVATIONS

ABBREVIATIONS

- | | |
|--------|-----------------------------|
| ADD'L | additional |
| AFF | above finished floor |
| AHU | air handling unit |
| ANOD | anodized |
| B.O. | by others |
| CAB | cabinet |
| CEIL G | ceiling |
| CL | center line |
| CLR | clear |
| CMU | concrete masonry unit |
| C.O. | cleanout |
| COL | column |
| CONC | concrete |
| C.P. | compactor |
| D | dryer |
| DBL | double |
| DIA | diameter |
| DIR | direction |
| DN | down |
| DR | door |
| D.W. | dishwasher |
| DWG | drawing |
| ELEC | electrical |
| ELEV | elevation |
| EQ | equal |
| EQUIP | equipment |
| EXIST | existing |
| EXT. | exterior |
| FF | finished floor |
| FIN | finished |
| FIXT. | fixture |
| FLR | floor |
| FLUOR | flourescent |
| FDN | foundation |
| GEN | general |
| GWB | gypsum wall board |
| HVAC | heat / vent / air-condition |
| INSUL | insulation |
| JT | joint |
| LOC | location / locate |
| L.V. | low-voltage |
| MAX | maximum |
| MIN | minimum |
| M.W. | microwave |
| MTD | mounted |
| NTS | not to scale |
| O.C. | on center |
| PTD | painted |
| P.T. | pressure treated |
| QTY | quantity |
| REG | register |
| REIN | reinforce |
| REQ'D | required |
| R.O. | rough opening |
| RM | room |
| RR | roof rafters |
| SIM | soffit |
| SOF | similar |
| SPEC | specification |
| SS | stainless steel |
| STL | steel |
| T | tread |
| T.B.D | to be determined |
| T&G | tongue in groove |
| THK | thick / thickness |
| T.R. | to remain |
| TYP | typical |
| U.S. | underside |
| VCT | vinyl composition tile |
| VERT. | vertical |
| V.I.F. | verify in field |
| W. | washing machine |
| W.D.W. | window |
| WD | wood |
| Z.C.C | zinc-coated copper |

SYMBOLS:

- | | |
|--|----------------------------------|
| | = DOOR # |
| | = EXT. DOOR TYPE |
| | = WINDOW TYPE |
| | = WALL TYPE |
| | = FINISH NOTE: SEE SCHEDULE DWG. |
| | = DETAIL |
| | = SECTION |
| | = ELEVATION |
| | = CUT LINE |
| | = SOFFIT / HGT. |

ZONING DIAGRAM

EXISTING
IMPERMEABLE AREA
3117 SF FOOTPRINT

PROPOSED IMPERMEABLE AREA
3120 SF FOOTPRINT
= 3117 SF FOOTPRINT

= 3 SQ FT < 350 SQ FT ALLOWED

S s D

171 BROOKLINE STREET
CAMBRIDGE, MA 02139

NA: 617.576.9300

www.ssdarchitect.com
info@ssdarchitect.com

CONSULTANTS:

STRUCTURAL ENGINEER:
SIMPSON CLARK PETER & WEEGER
41 SEVEN STREET
WALTHAM, MA 02453

NA: 781.907.9000
loc: 781.907.9009
www.sgi.com

SURVEYOR:
AGI ENGINEERING
166 WATER STREET
STOUGHTON, MA

PROJECT:

Travers-Smith Residence

PROJECT ADDRESS:

119 PARK AVENUE
ARLINGTON, MA 02476

DWG TITLE:

COVER SHEET

SEAL & SIGNATURE:

DATE: 11 JUNE 2019

PROJECT No.: 1012

DWG BY: WW.BB.CC.LM.SC.JC.EV.TH

CHK BY: JH

DWG NO.: A-000

DOB ID No.:

PAGE No.:

LIGHT FIXTURES

FIXTURE	MANUF.	MODEL #	FINISH	BULB
RECESSED - 4"	WAC	R-420	WHITE	R20-50w
RECESSED - 5"	WAC			
P-1 PENDANT	TBD			
P-2 PENDANT	TBD			
W-1 WALL MT'D. LIGHT	TBD			
X-1 LANDSCAPE UPLIGHT	TBD			
X-2 EXTERIOR LIGHT	TBD			
X-3 EXTERIOR LIGHT	TBD			
EXTERIOR DOWNLIGHT	TBD			
LED STRIP LIGHT				
FLOURESCENT STRIP LIGHT W/ PLASTIC COVER	GENERIC		WHITE	WARM WHITE - SEE DWGS. FOR LENGTHS
LOW-VOLT PUCK-LIGHT	WAC		WHITE	

NOTES


- COORD. ALL APPLIANCE OUTLETS W/ EQUIPMENT
- SUBSTITUTIONS TO BE SUBMITTED TO ARCHITECT AND/OR OWNER FOR APPROVAL
- CABLE OUTLETS MUST ALWAYS BE LOCATED IN CLOSE PROXIMITY TO DUPLEX OUTLET.
- ALL PHOTOCELL / MOTION SENSOR LOCATIONS ARE TO BE DETERMINED IN THE FIELD FOR EFFECTIVENESS; DRAWINGS SHOW SUGGESTED LOCATIONS ONLY.
- ALL LANDSCAPE LIGHTING TO BE COORDINATED W/ LANDSCAPE DESIGN
- ARROWS FROM HVAC MAIN TRUNKS SHOW DIRECTION OF BRANCH DUCTS ONLY; EXACT NO. & LOC. TO BE COORD. IN BY LICENSED HVAC CONTRACTOR.
- ALL EXPOSED CONDUITS & DUCTWORK TO BE OF FINISHED QUALITY - CONTRACTOR TO SUBMIT SAMPLE. PAINT PER ROOM SCHEDULES.
- ELEC. RECEPTACLES @ CONC. WALLS IN GARAGE & BASEMENT TO HAVE EXPOSED MTL. CONDUIT & J-BOX U.O.B.
- FINAL LOC'S & QUANTITY OF FLOOR OUTLETS TO BE COORDINATED W/ OWNER'S FURNITURE LAYOUT PLAN.
- FINAL ELECTRICAL & MECHANICAL WORK BY LICENSED CONTRACTORS IN ACCORDANCE W/ MASS. ELEC. CODE (527 CMR 12.00) & MASS. HVAC CODE (780 CMR 3614).
- ALL ELEC., TEL., DSL, CABLE CONNECTIONS TO HOUSE THRU UNDERGROUND CONDUITS - ADHERE TO ALL LOCAL PERMITTING PROCESSES & CODES.
- OUTLETS/CONNECTIONS TO APPLIANCES/EQUIP. SHOWN SCHEMATICALLY - REFER TO MANUF. SPEC'S. FOR ALL OUTLETS AND/OR ELEC./GAS CONNECTIONS TO APPLIANCES & EQUIP.
- COORDINATE WALL LIGHTING AND KITCHEN ELECTRIC WITH SIEMATIC.
- EXISTING PLUGS TO REMAIN UNLESS OTHERWISE NOTED
- ALL GFI OUTLETS OVER COUNTERS UNLESS OTHERWISE NOTED.

RCP LEGEND & NOTES

NTS


DEVICES / EQUIPMENT

- DUPLEX OUTLET
- DUPLEX OUTLET - EXTERIOR GFI W/ COVER
- QUAD. OUTLET
- QUAD. OUTLET - UNDERCOUNTER
- APPLIANCE OUTLET
- LUTRON 'DIVA' SWITCH - SEE PLAN FOR TYPE
- LUTRON 'DIVA' DIMMER
- DATA/VOICE JACK
- CABLE TV JACK
- BATHROOM EXHAUST FAN
- PHOTOCELL
- MOTION DETECTOR
- PHOTOCELL W/ MOTION DETECTOR
- SMOKE DETECTOR
- HEAT DETECTOR
- CARBON MONOXIDE
- THERMOSTAT
- ELEC. SUBPANEL
- MAIN TRUNK
- BRANCH DUCT
- DIFFUSER

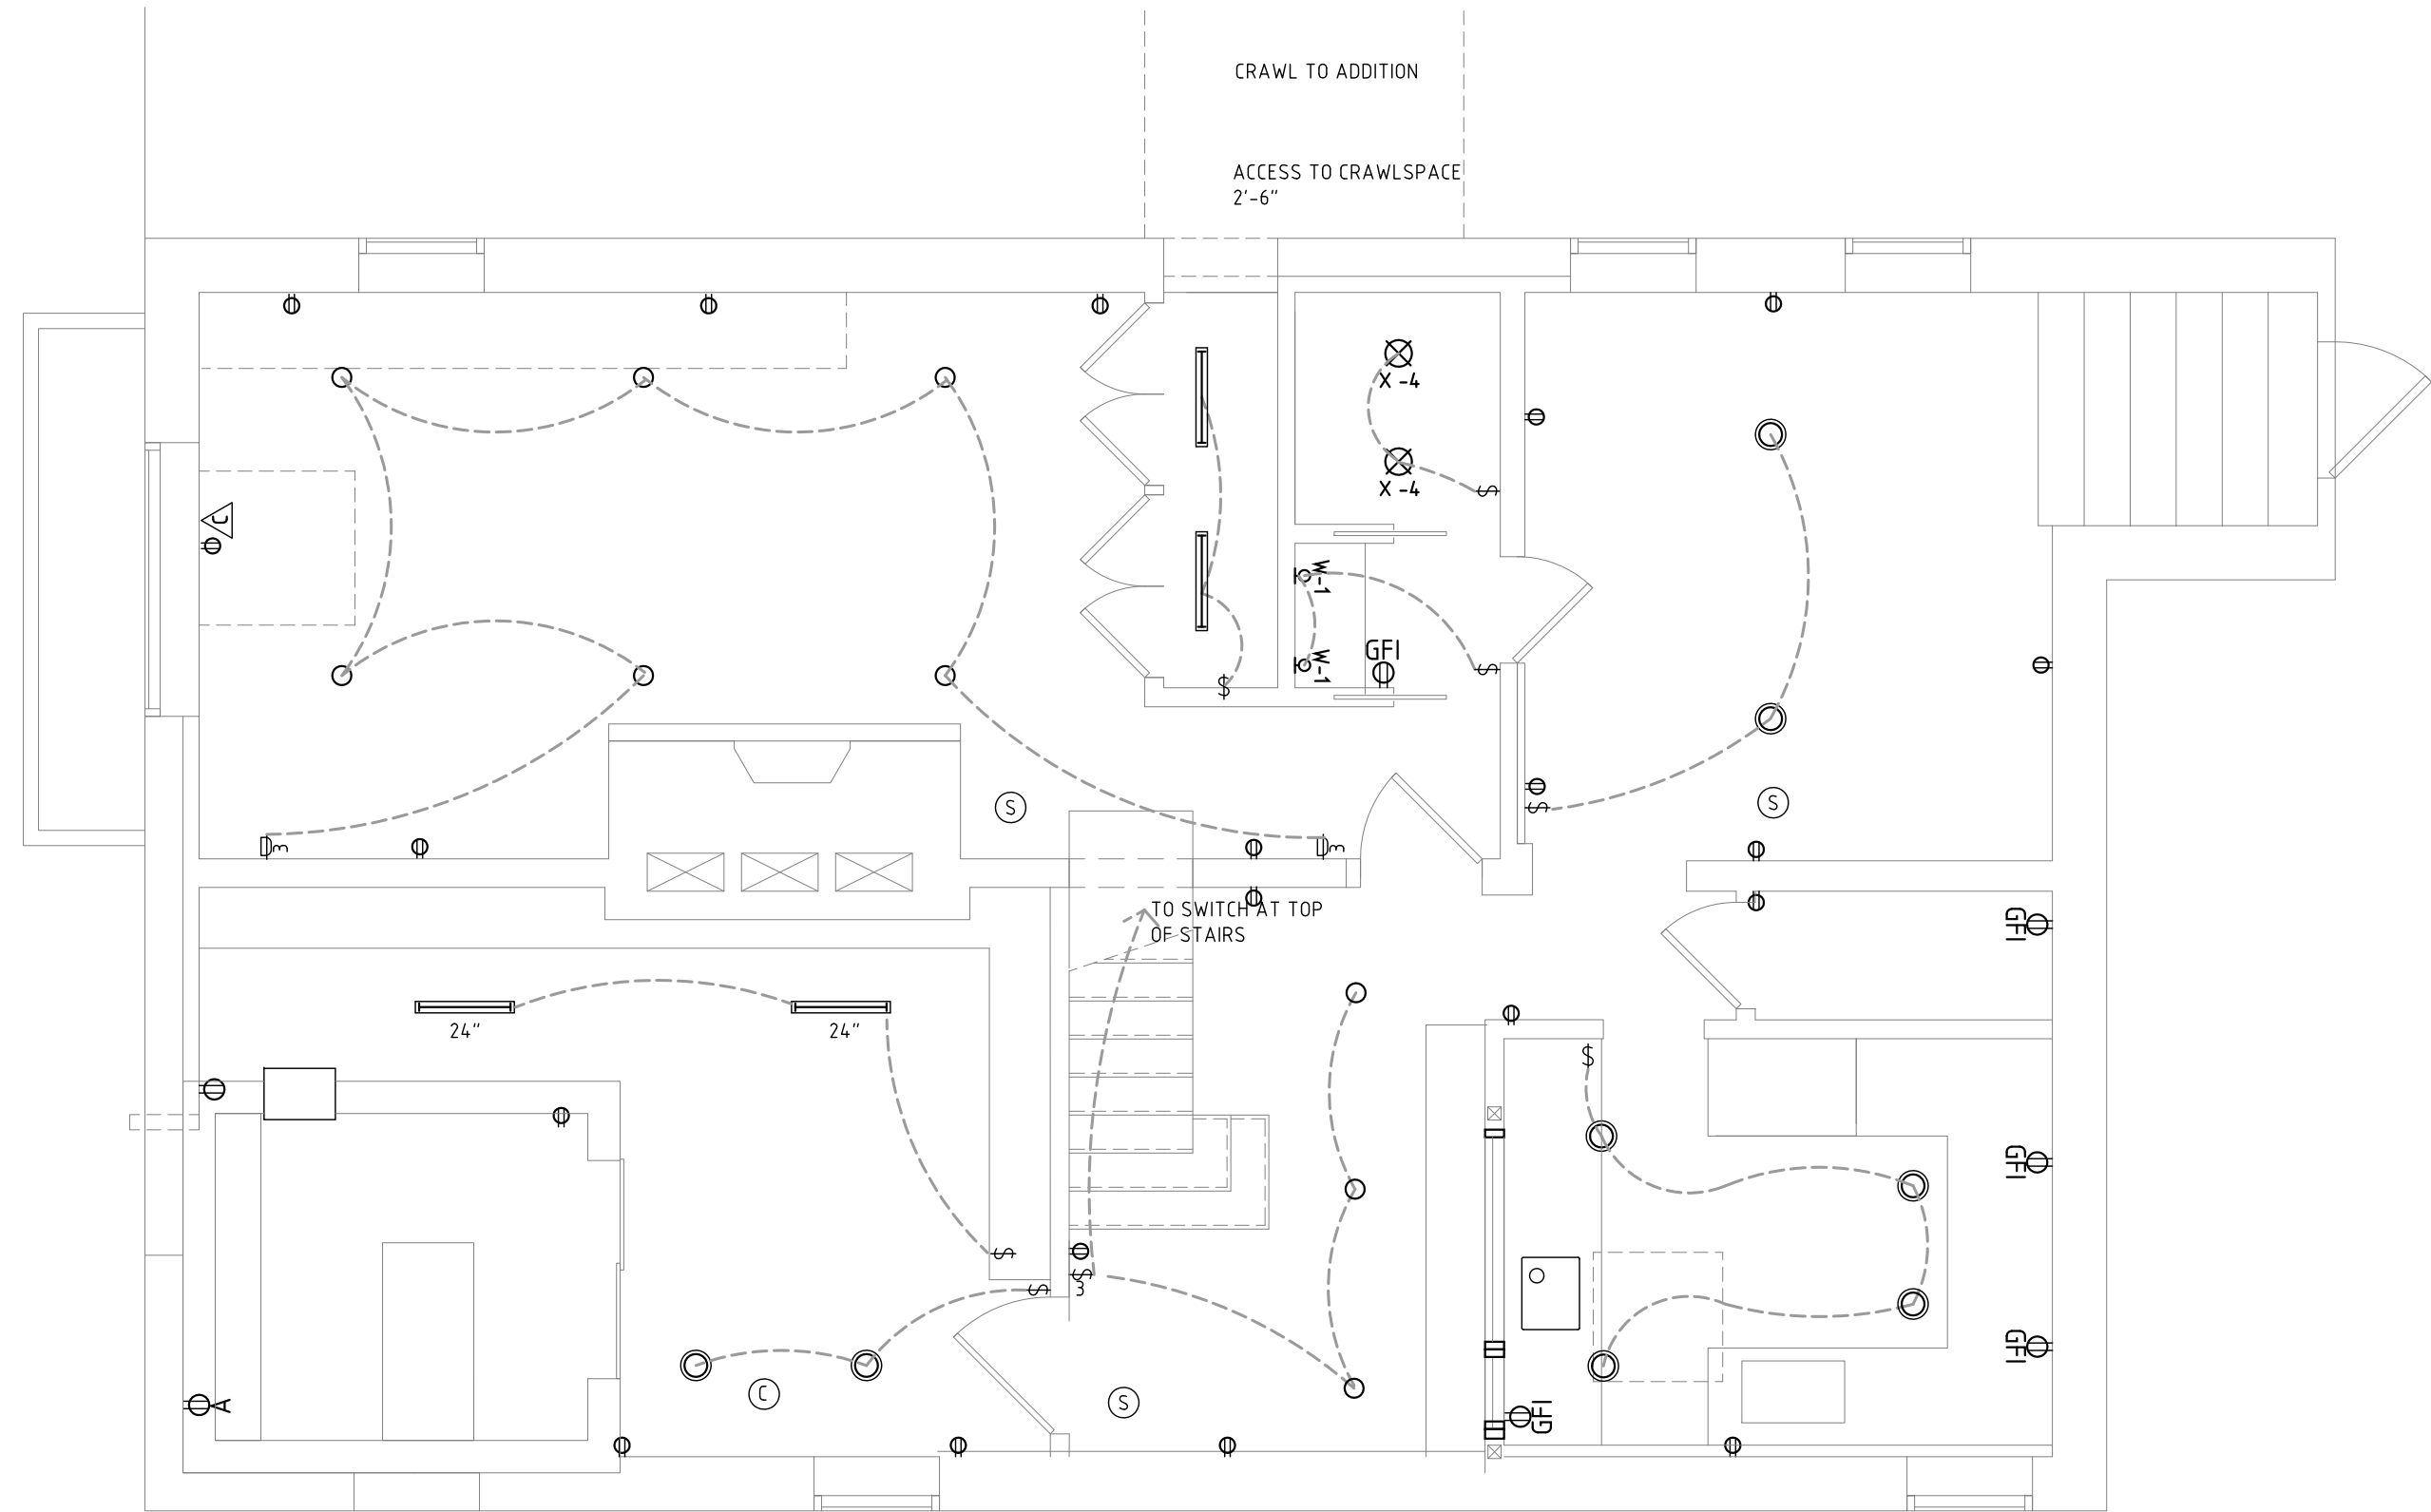

BASEMENT RCP

1/4"=1'

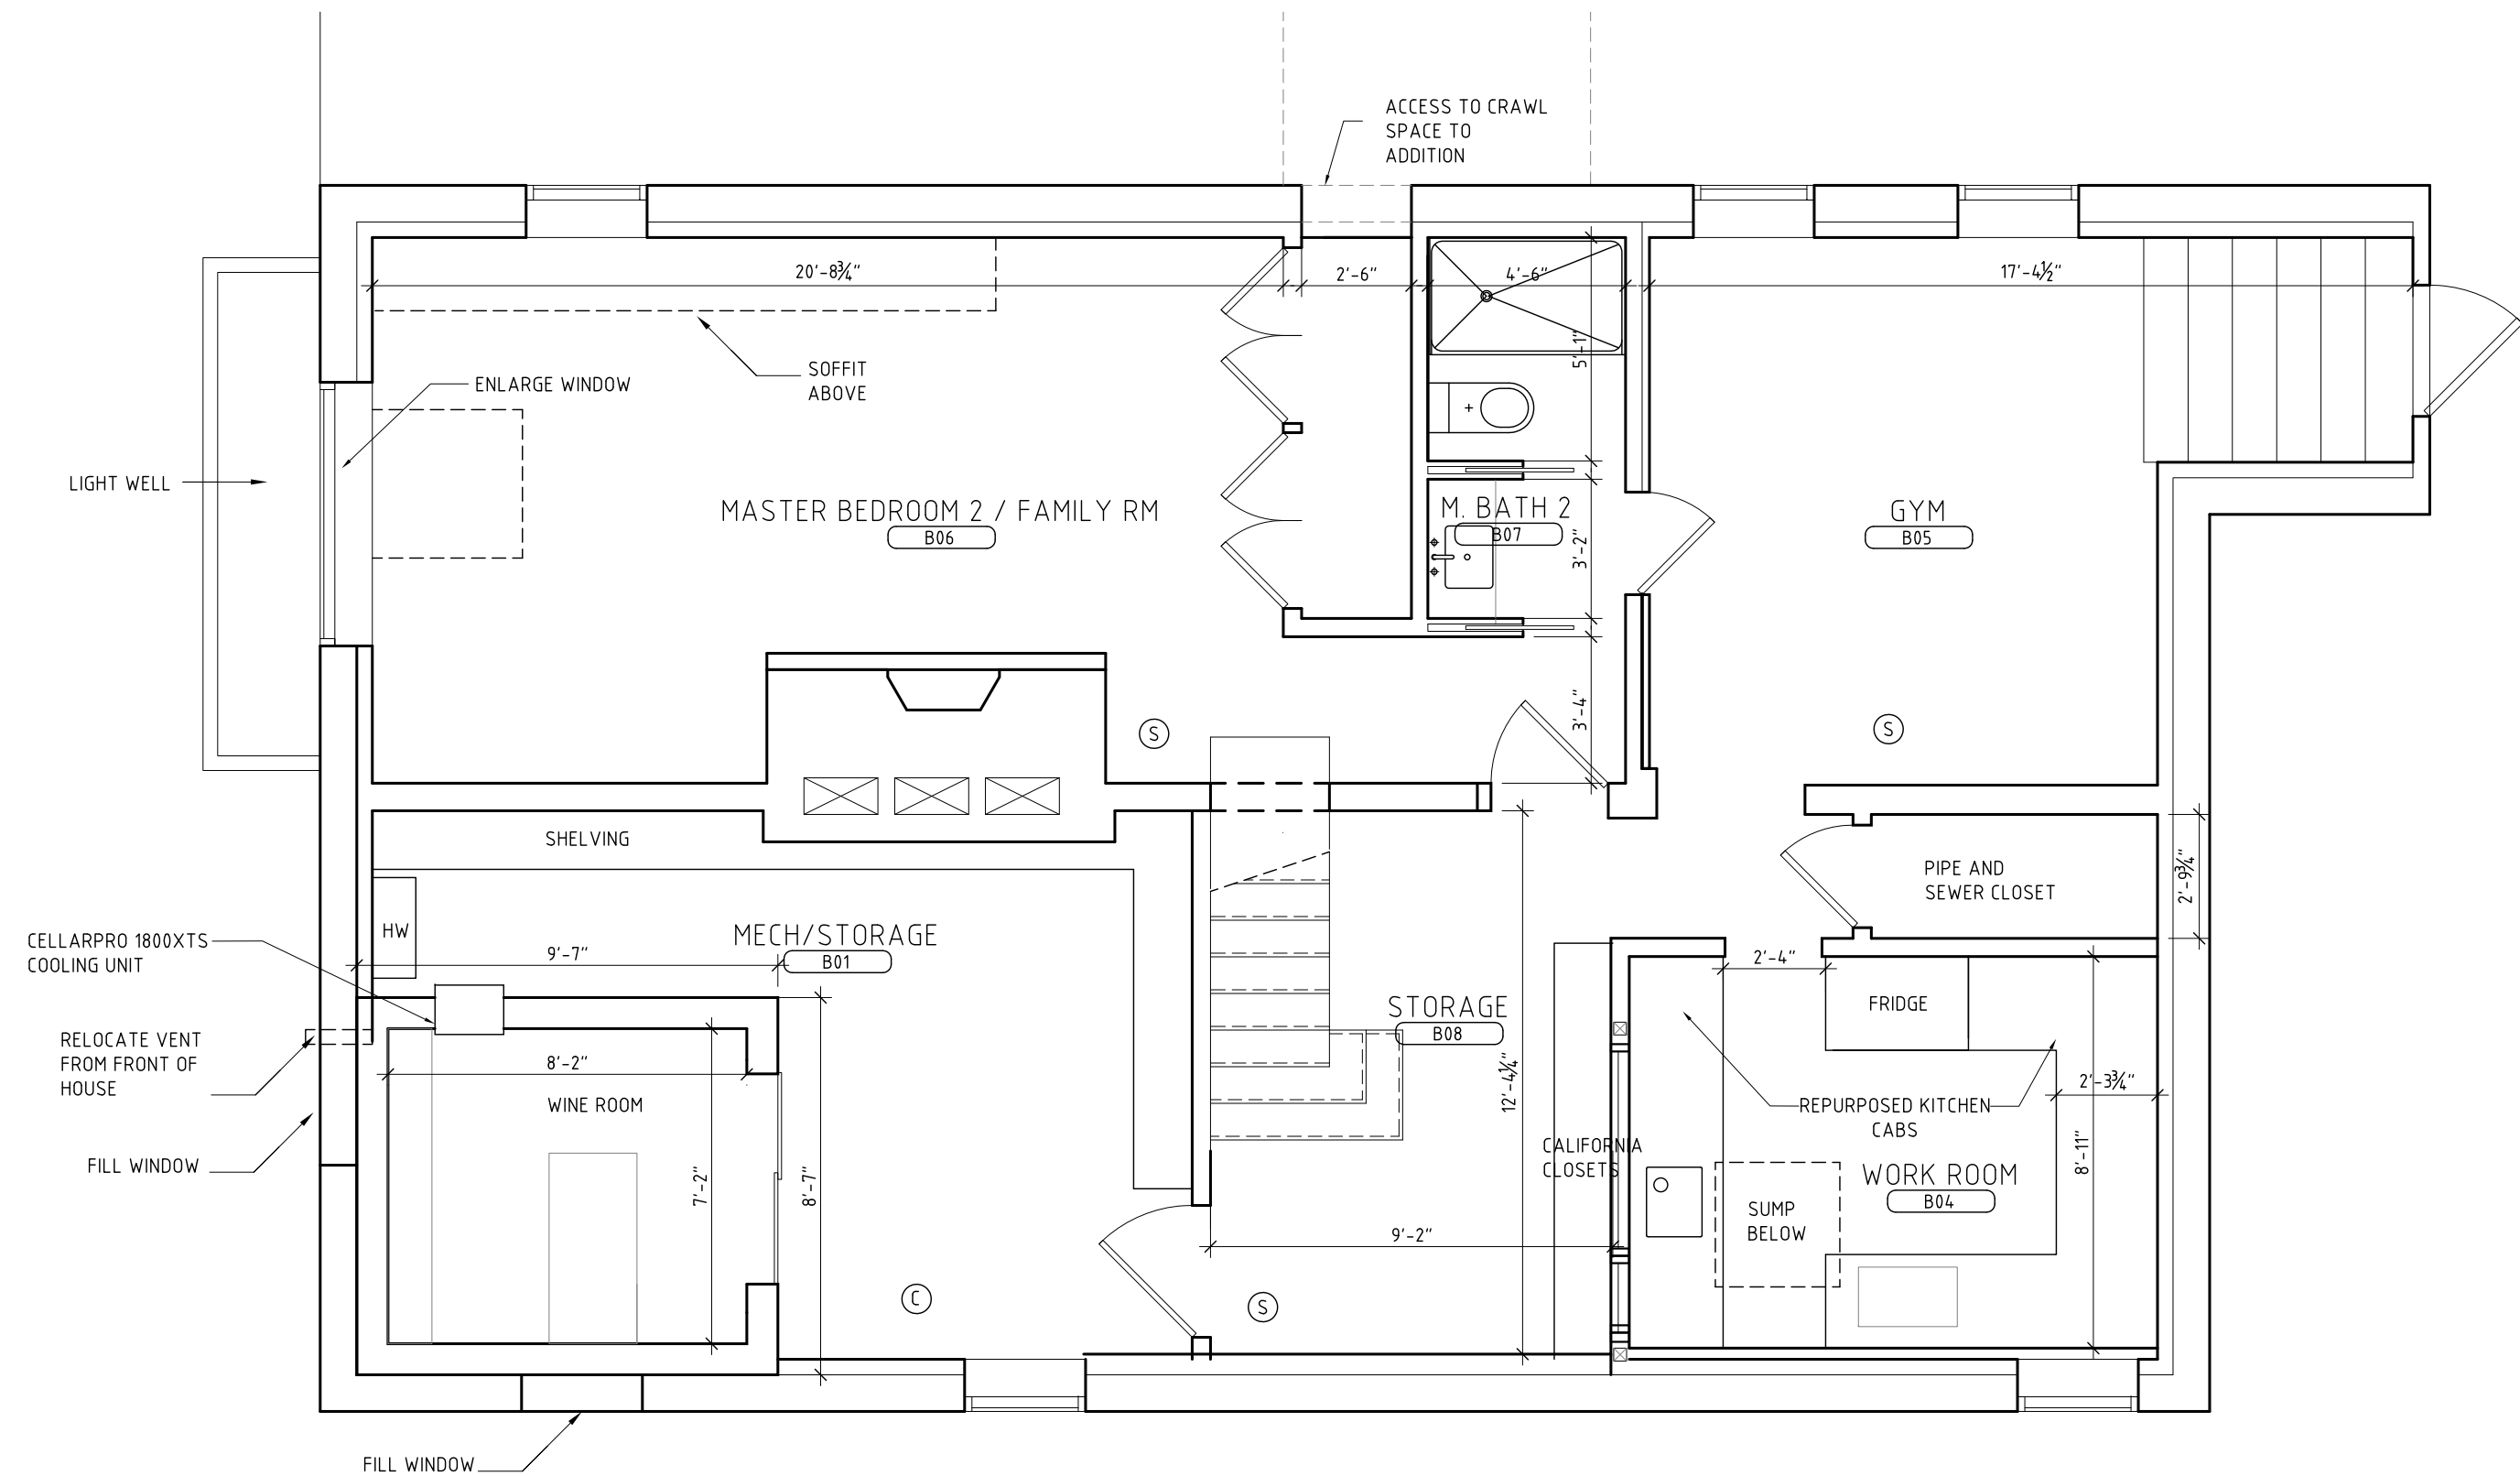

BASEMENT FLOOR PLAN

1/4"=1'

S s D

171 BROOKLINE STREET
CAMBRIDGE, MA 02139
NA/Tel: 617. 576. 9300
www.ssdarchitecture.com
info@ssdarchitecture.com

CONSULTANTS:

STRUCTURAL ENGINEER:
SIMPSON CLAMPERT & WEEGER
41 SEVEN STREET
BUILDING 1, SUITE 200
WALTHAM, MA 02453
NA: 781. 907. 9000
tc: 781. 907. 9009
www.scd.com

SURVEYOR:
AGI ENGINEERING
156 WATER STREET
STOUGHTON, MA

PROJECT:

Travers-Smith Residence

PROJECT ADDRESS:

119 PARK AVENUE
ARLINGTON, MA 02476

DWG TITLE:

BASEMENT PLAN & RCP

SEAL & SIGNATURE:

DATE: 11 JUNE 2010

PROJECT No.: 1012

DWG BY: WW.BB.CC.LM.SC.JC.EV.TH

DWG BY: JH

DWG No.:

DOB ID No.:

PAGE No.:

© 2010 S&S Design LLC. All rights reserved. No part of this drawing may be reproduced without written permission from S&S Design LLC.

A-101



CONSULTANTS:

STRUCTURAL ENGINEER:
SIMPSON CLARK PETER & WESSER
41 SEVEN STREET
BOSTON 1, SUITE 200
WALTHAM, MA 02453

MA 781. 907. 9000
fax 781. 907. 9009
www.spe.com

SURVEYOR:
AGI ENGINEERING
156 WATER STREET
STOUGHTON, MA

PROJECT:

Travers-Smith Residence

PROJECT ADDRESS:

119 PARK AVENUE
ARLINGTON, MA 02476

DWG TITLE:

ROOF PLAN

SEAL & SIGNATURE:

DATE: 11 JUNE 2019

PROJECT No.: 1012

DWG BY: WW,BB,CC,LM,SC,JC,EV,TH


DWG BY: JH

DWG NO.:


DOB ID No.:

PAGE No.:

A-103

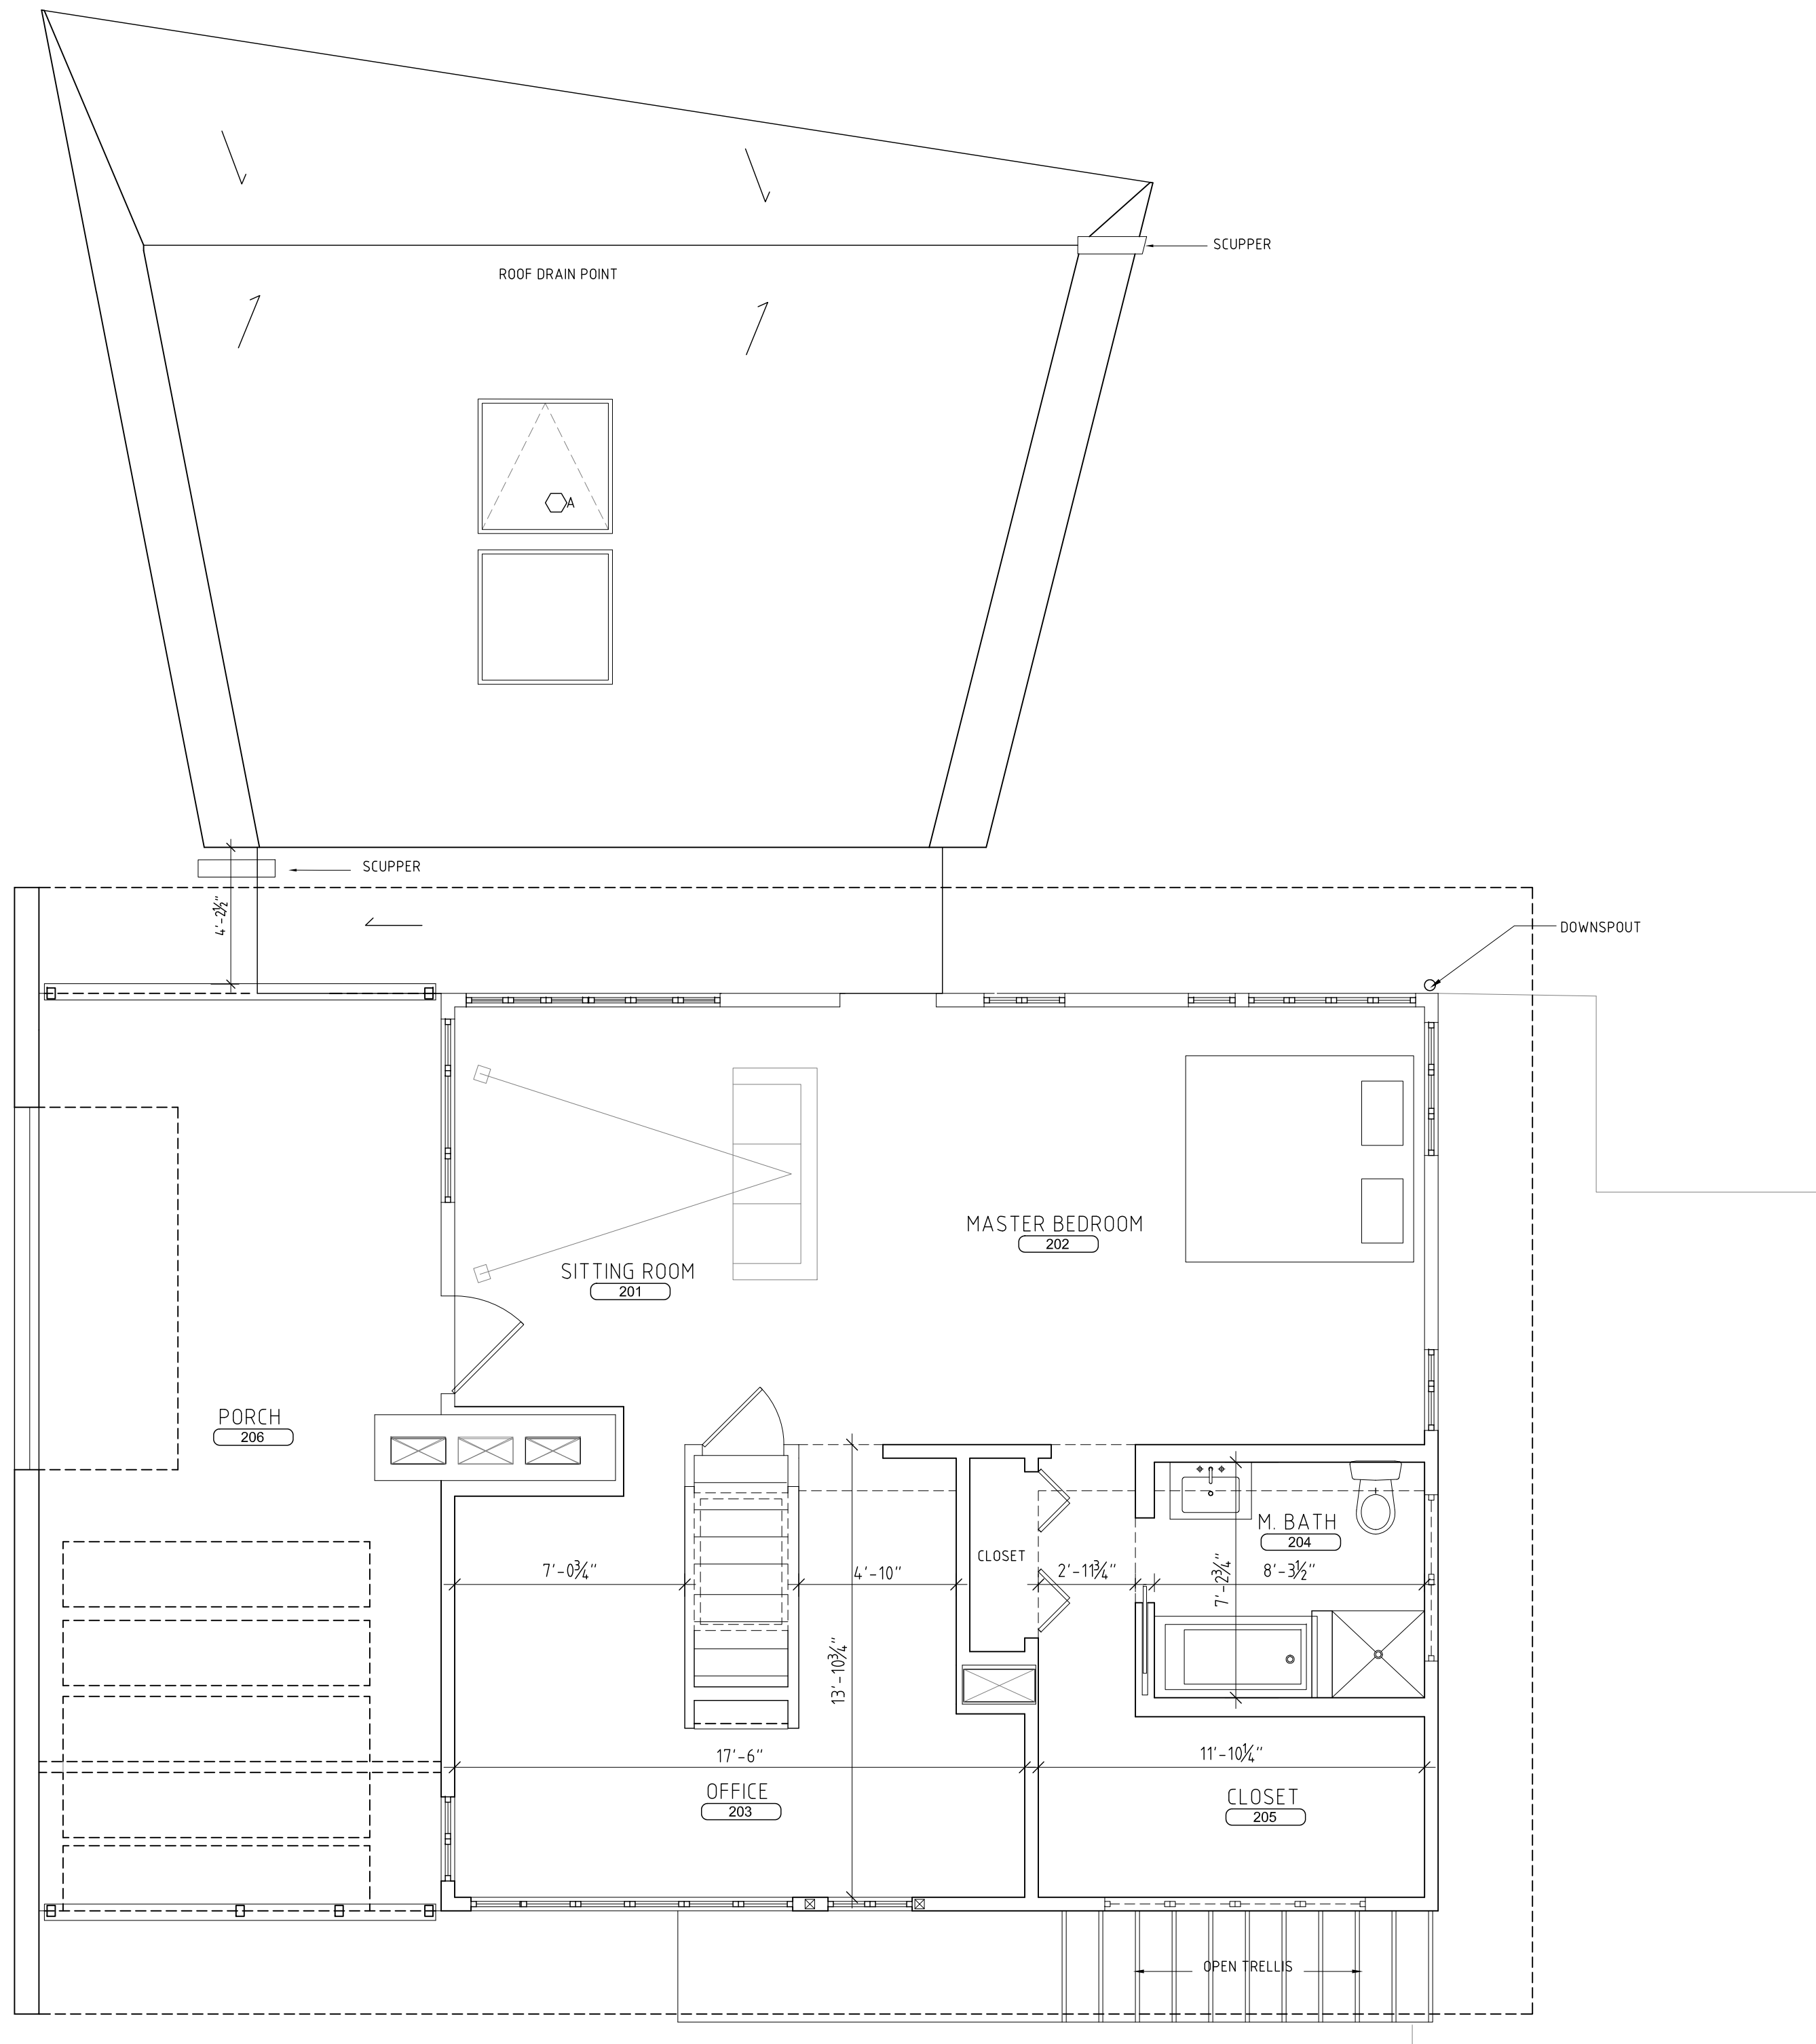

1 ROOF PLAN
1/4"=1'

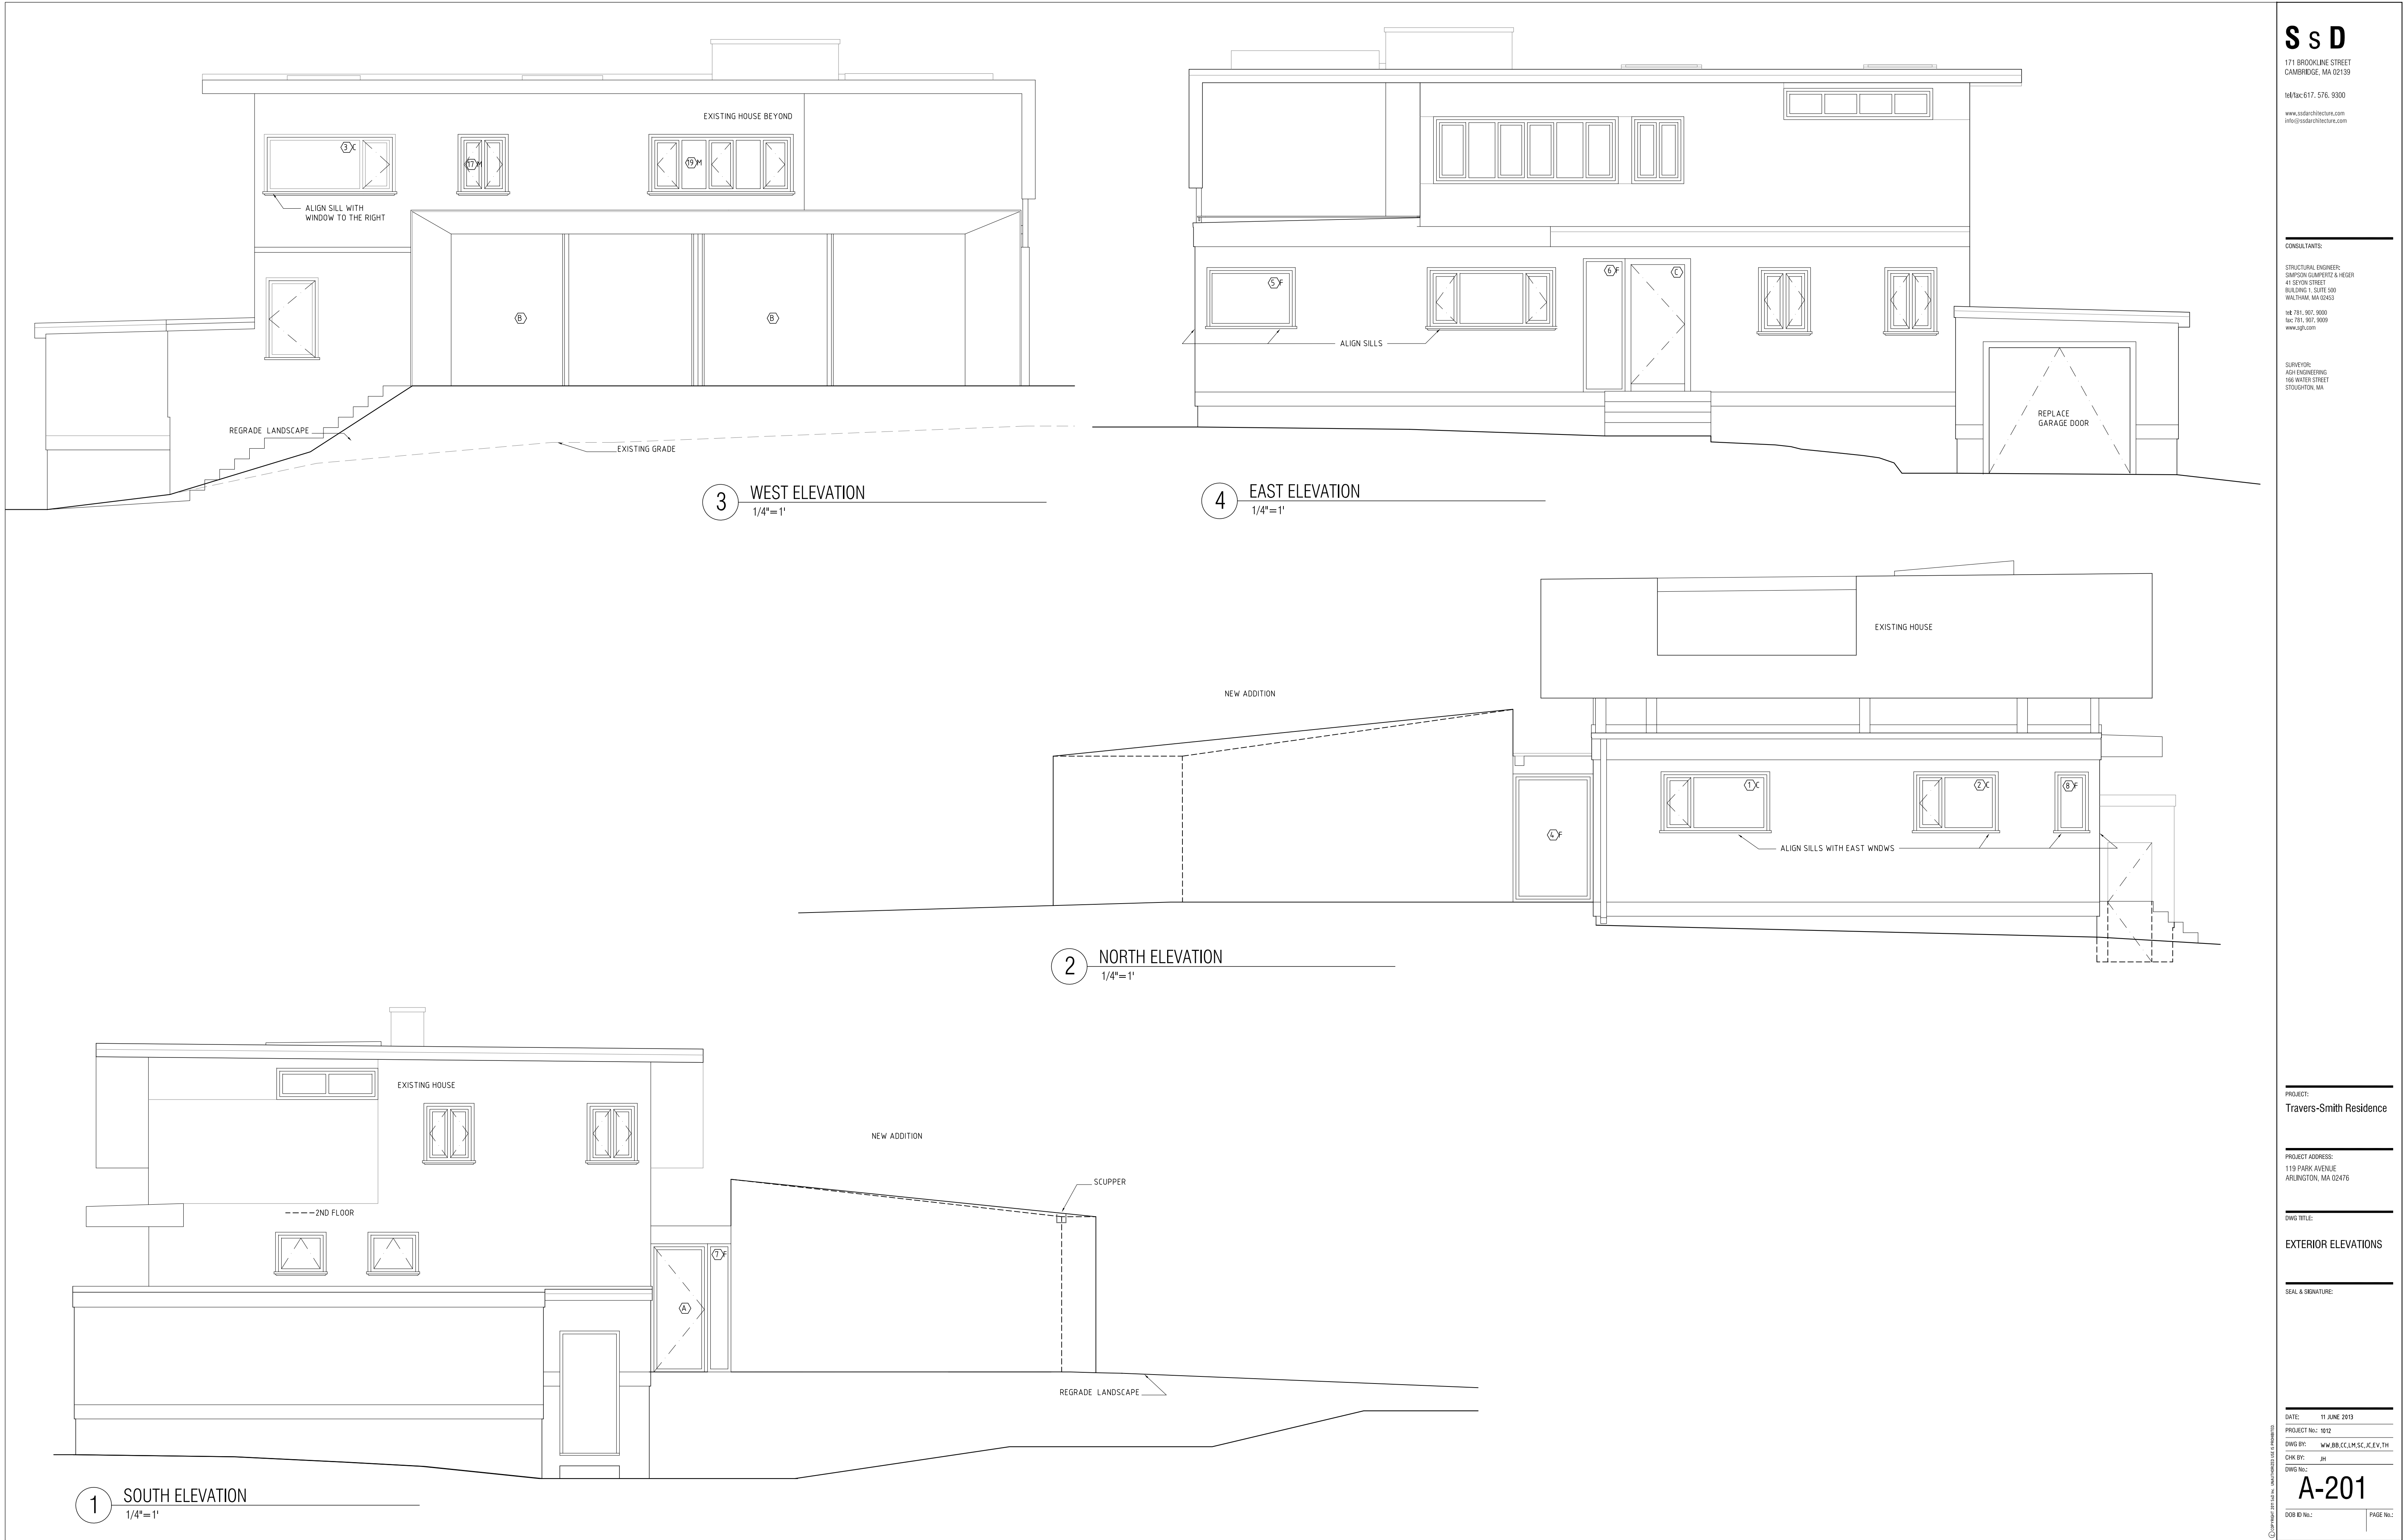

S s D

171 BROOKLINE STREET
CAMBRIDGE, MA 02139

MA 617. 576. 9300

www.ssdarchitecture.com
info@ssdarchitecture.com

CONSULTANTS:

STRUCTURAL ENGINEER:
SIMPSON CLARK & WESSER
41 SEVEN STREET
BOSTON, MA 02108

MA 781. 907. 9000
fax 781. 907. 9009
www.sgi.com

SURVEYOR:

AGI ENGINEERING
156 WATER STREET
STOUGHTON, MA

PROJECT:

Travers-Smith Residence

PROJECT ADDRESS:

119 PARK AVENUE
ARLINGTON, MA 02476

DWG TITLE:

EXTERIOR ELEVATIONS

SEAL & SIGNATURE:

DATE:

11 JUNE 2019

PROJECT No.:

1012

DWG BY:

WW.BB.CC.LM.SC.JC.EV.TH

DWG NO.:


JH

DOB NO.:


PAGE No.:

A-201


WINDOWS

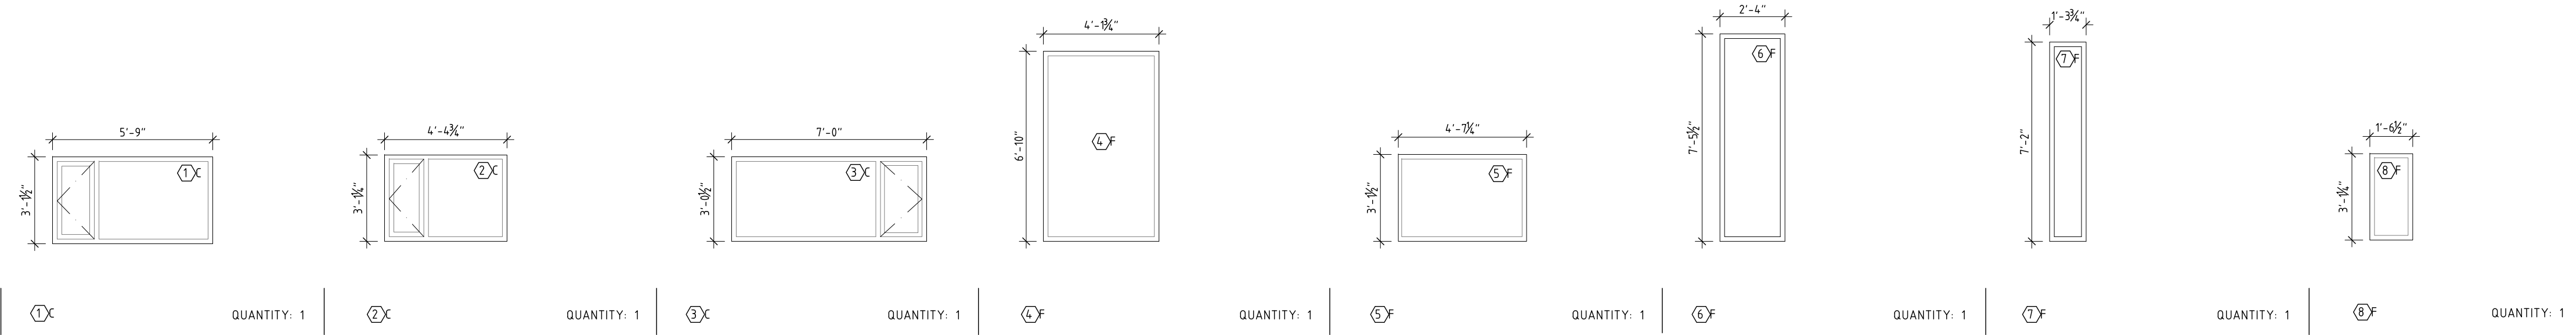

VELUX SKYLIGHT

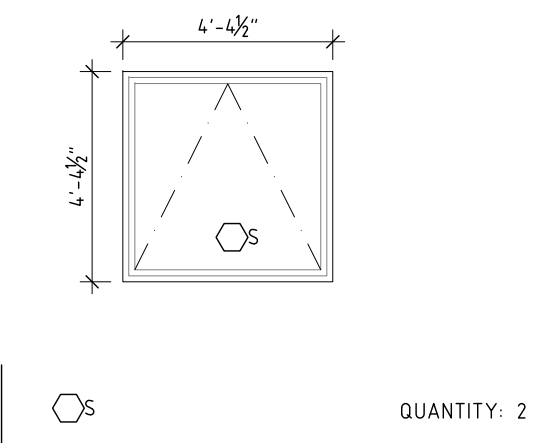

DOORS

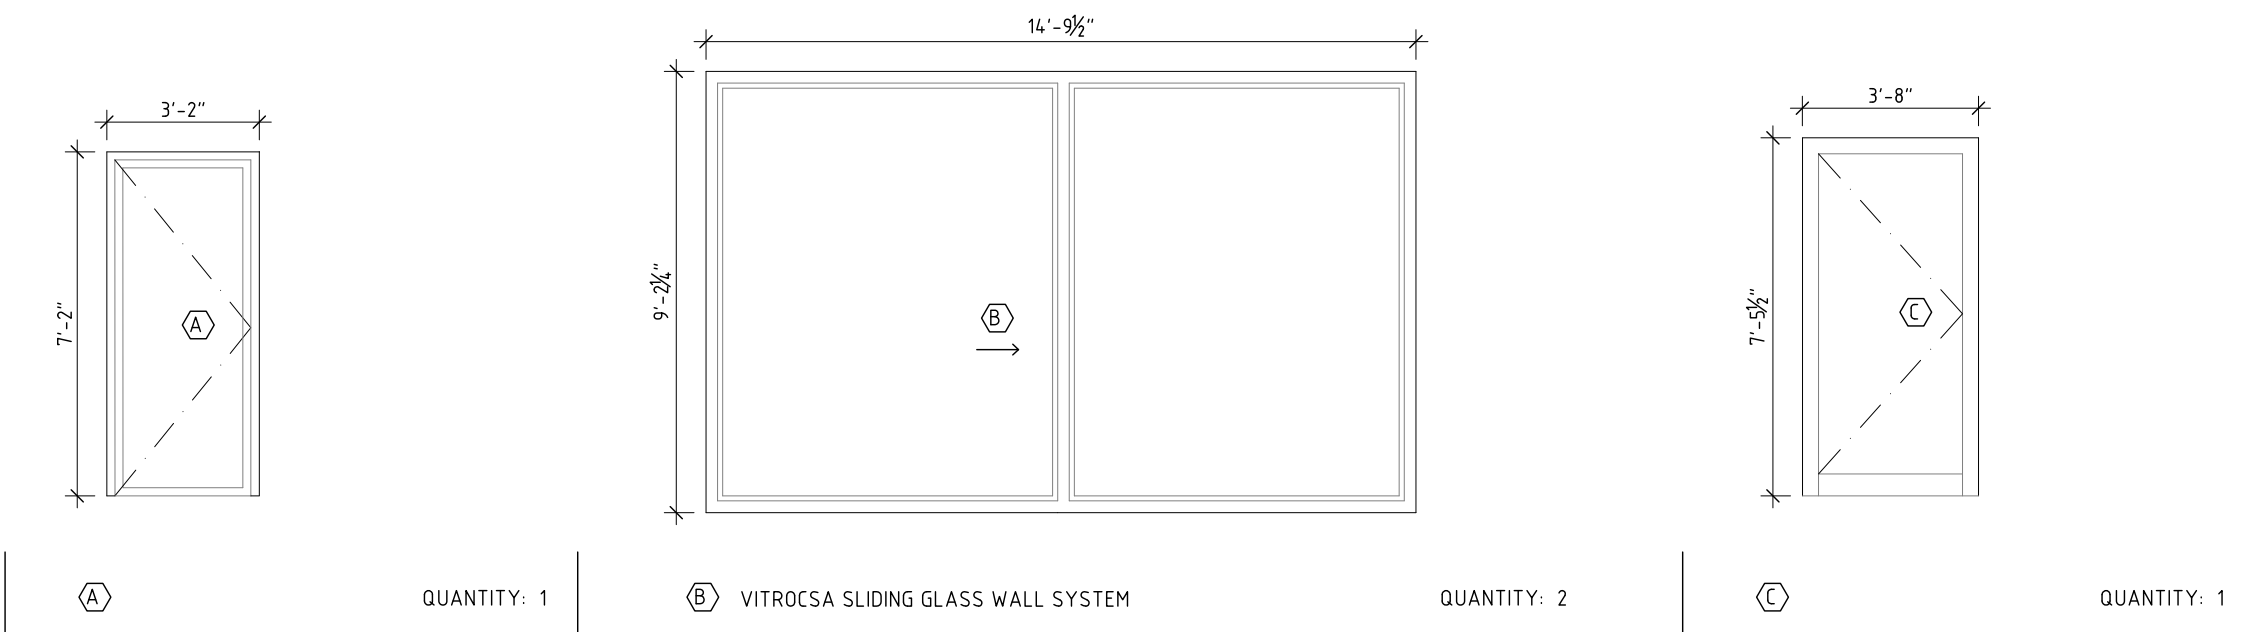

WINDOW NOTES

1. ALL WINDOWS ANODIZED ALUM."STOREFRONT", EXCEPT SLIDING DOOR TYPE B
2. LOW-E INSULATED GLASS ON ALL WINDOWS
3. THERMAL BREAK ON ALL WINDOW SYSTEMS

S s D

171 BROOKLINE STREET
CAMBRIDGE, MA 02139
NA/Tel: 617. 576. 9300
www.ssdsarchitecture.com
info@ssdsarchitecture.com

CONSULTANTS:

STRUCTURAL ENGINEER:
SIMPSON CLAMPERTZ & WESSER
41 SEVEN STREET
BUILDING 1, SUITE 200
WALTHAM, MA 02453
NA: 781. 907. 9000
tel: 781. 907. 9009
www.sgi.com

SURVEYOR:
AGI ENGINEERING
166 WATER STREET
STOUGHTON, MA

PROJECT:

Travers-Smith Residence

PROJECT ADDRESS:

119 PARK AVENUE
ARLINGTON, MA 02476

DWG TITLE:

WINDOW SCHEDULE

SEAL & SIGNATURE:

DATE: 11 JUNE 2019

PROJECT No.: 1012


DWG BY: WW,BB,CC,LM,SC,JC,EV,TH

DWG NO.: JH

A-202

DOB ID No.:

PAGE No.:

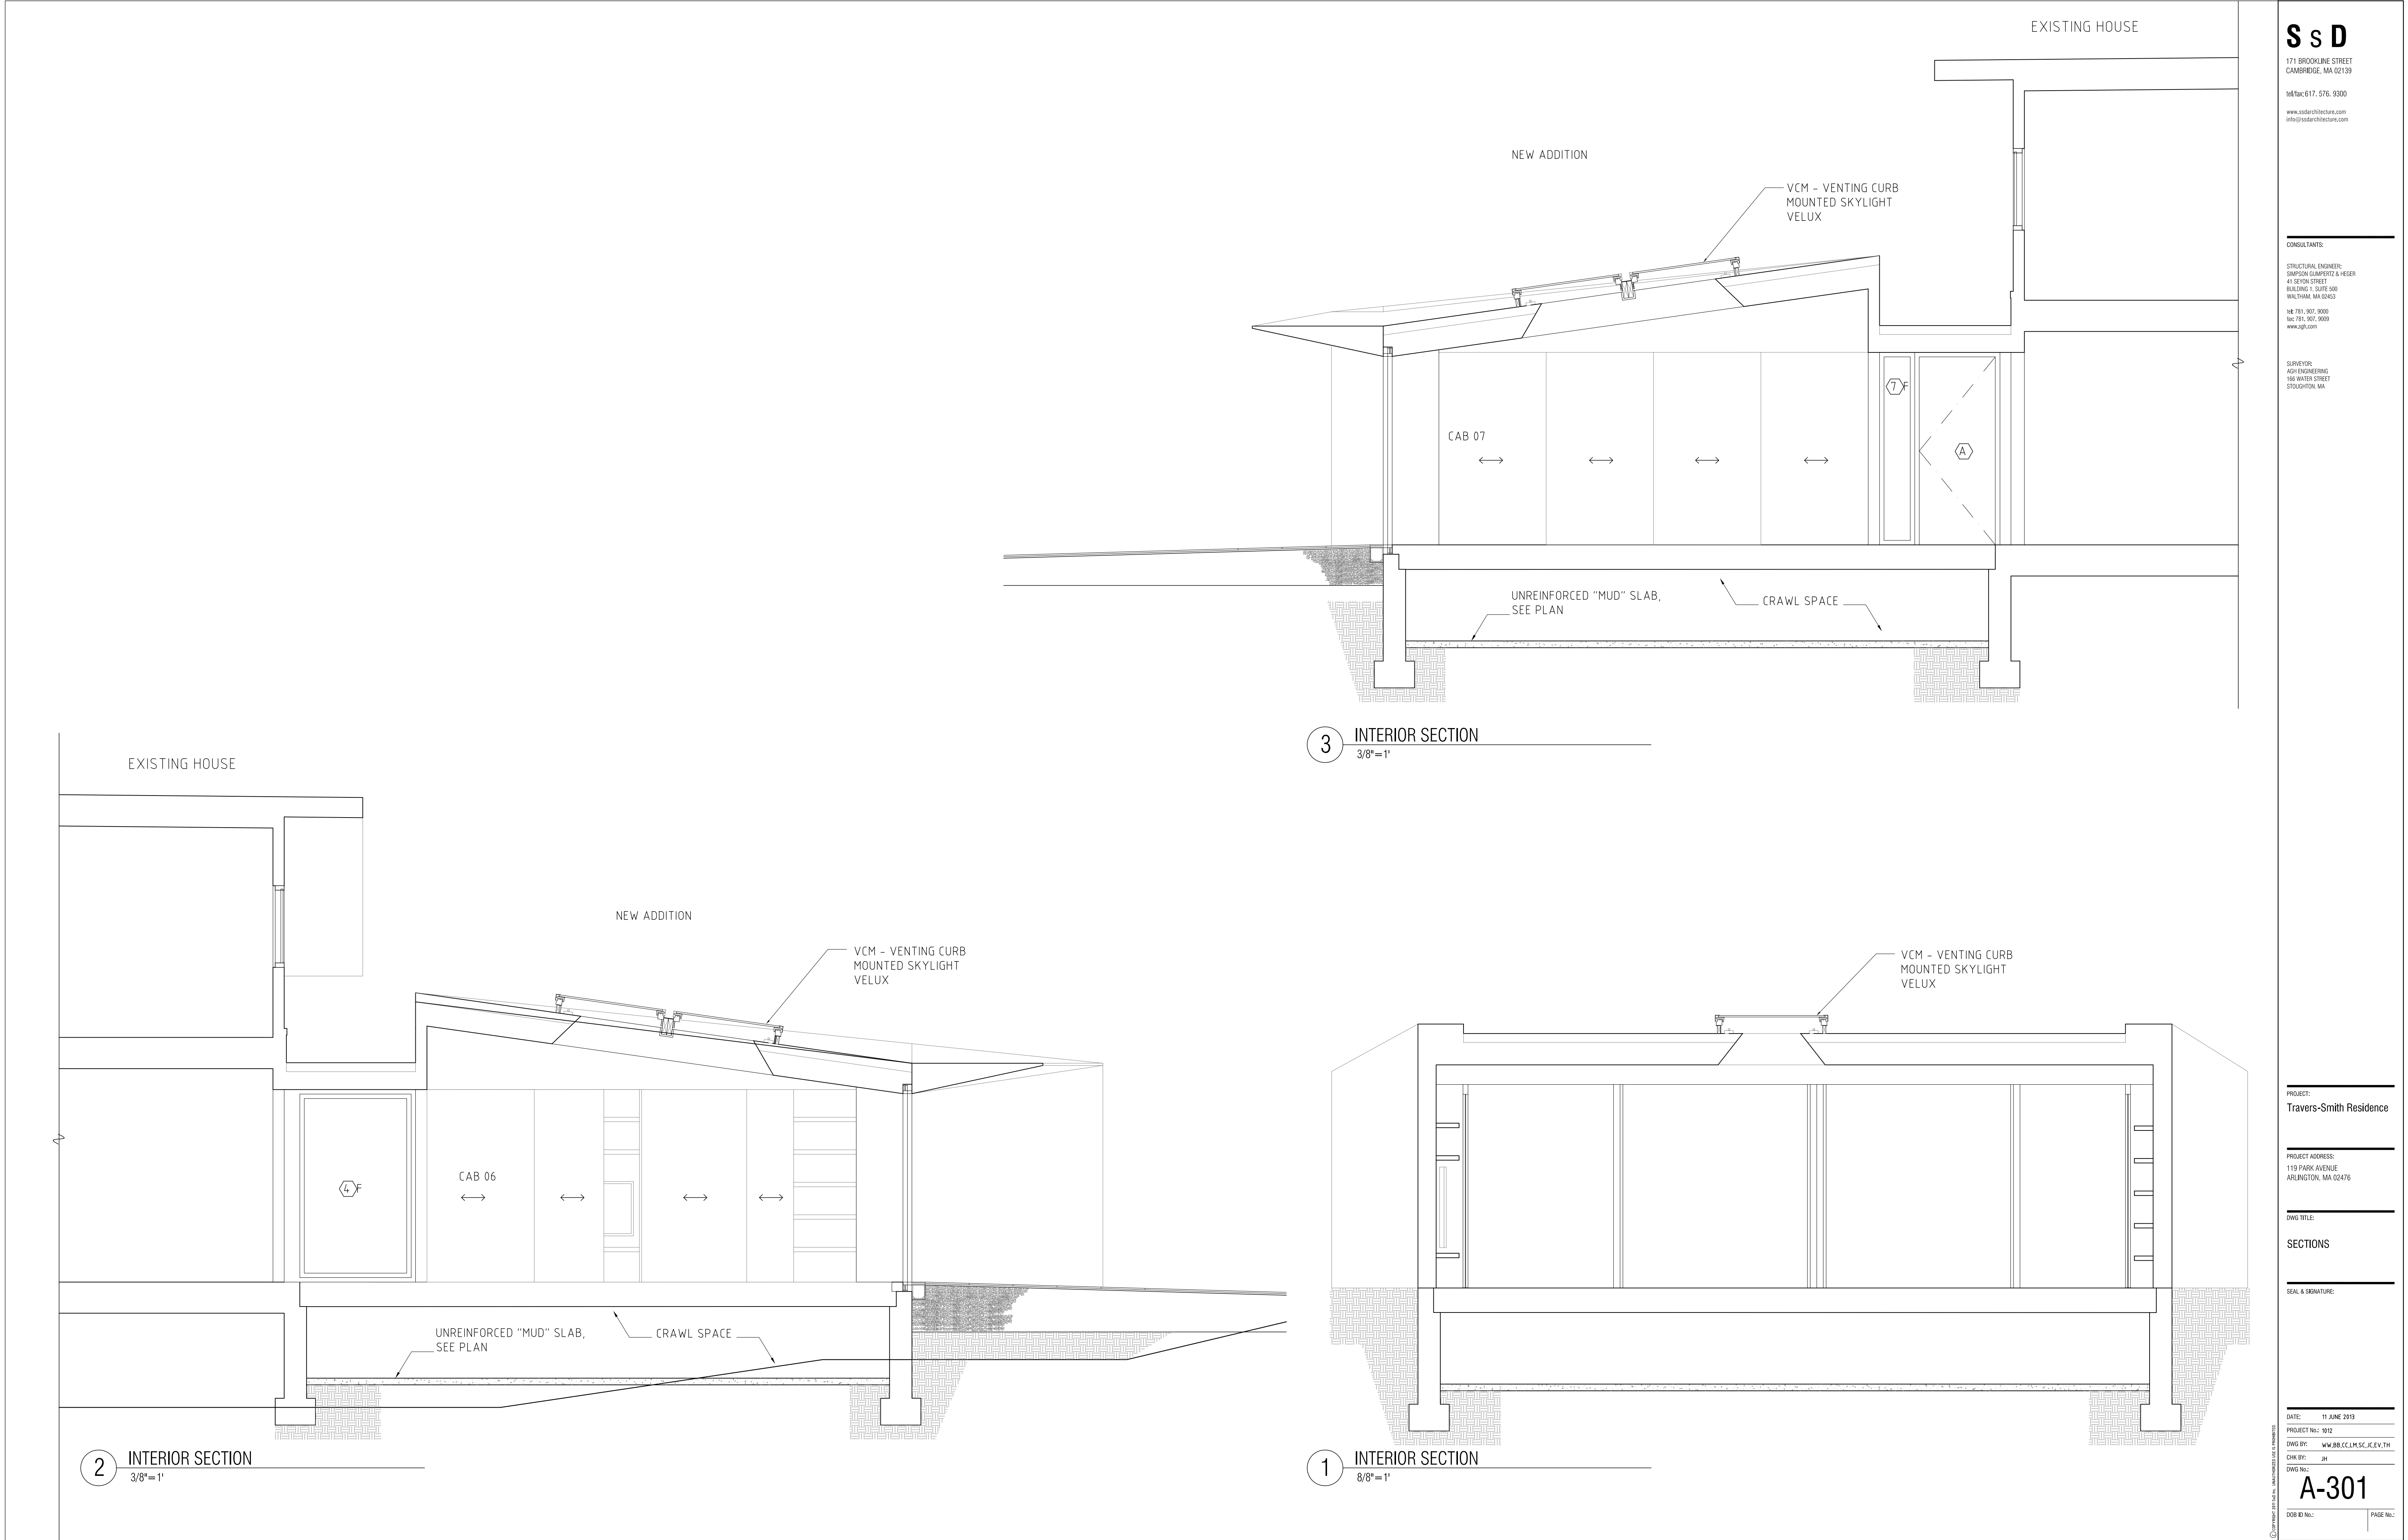

S s D

171 BROOKLINE STREET
CAMBRIDGE, MA 02139

tel: 617.576.9300

www.ssdarchitecture.com
info@ssdarchitecture.com

CONSULTANTS:

STRUCTURAL ENGINEER:
SIMPSON CLARK & WESSER
41 SEVEN STREET
BOSTON, MA 02108

MA 781.907.9000
tel: 781.907.9009
www.agi.com

SURVEYOR:

AGI ENGINEERING
150 WATER STREET
STOUGHTON, MA

PROJECT:

Travers-Smith Residence

PROJECT ADDRESS:

119 PARK AVENUE
ARLINGTON, MA 02476

DWG TITLE:

SECTIONS

SEAL & SIGNATURE:

DATE: 11 JUNE 2019

PROJECT No.: 1012


DWG BY: WW.BB.CC.LLM.SC.JC.EV.TH

DWG NO.: JH


DWG NO.: JH

DOB ID No.: PAGE No.:


A-301

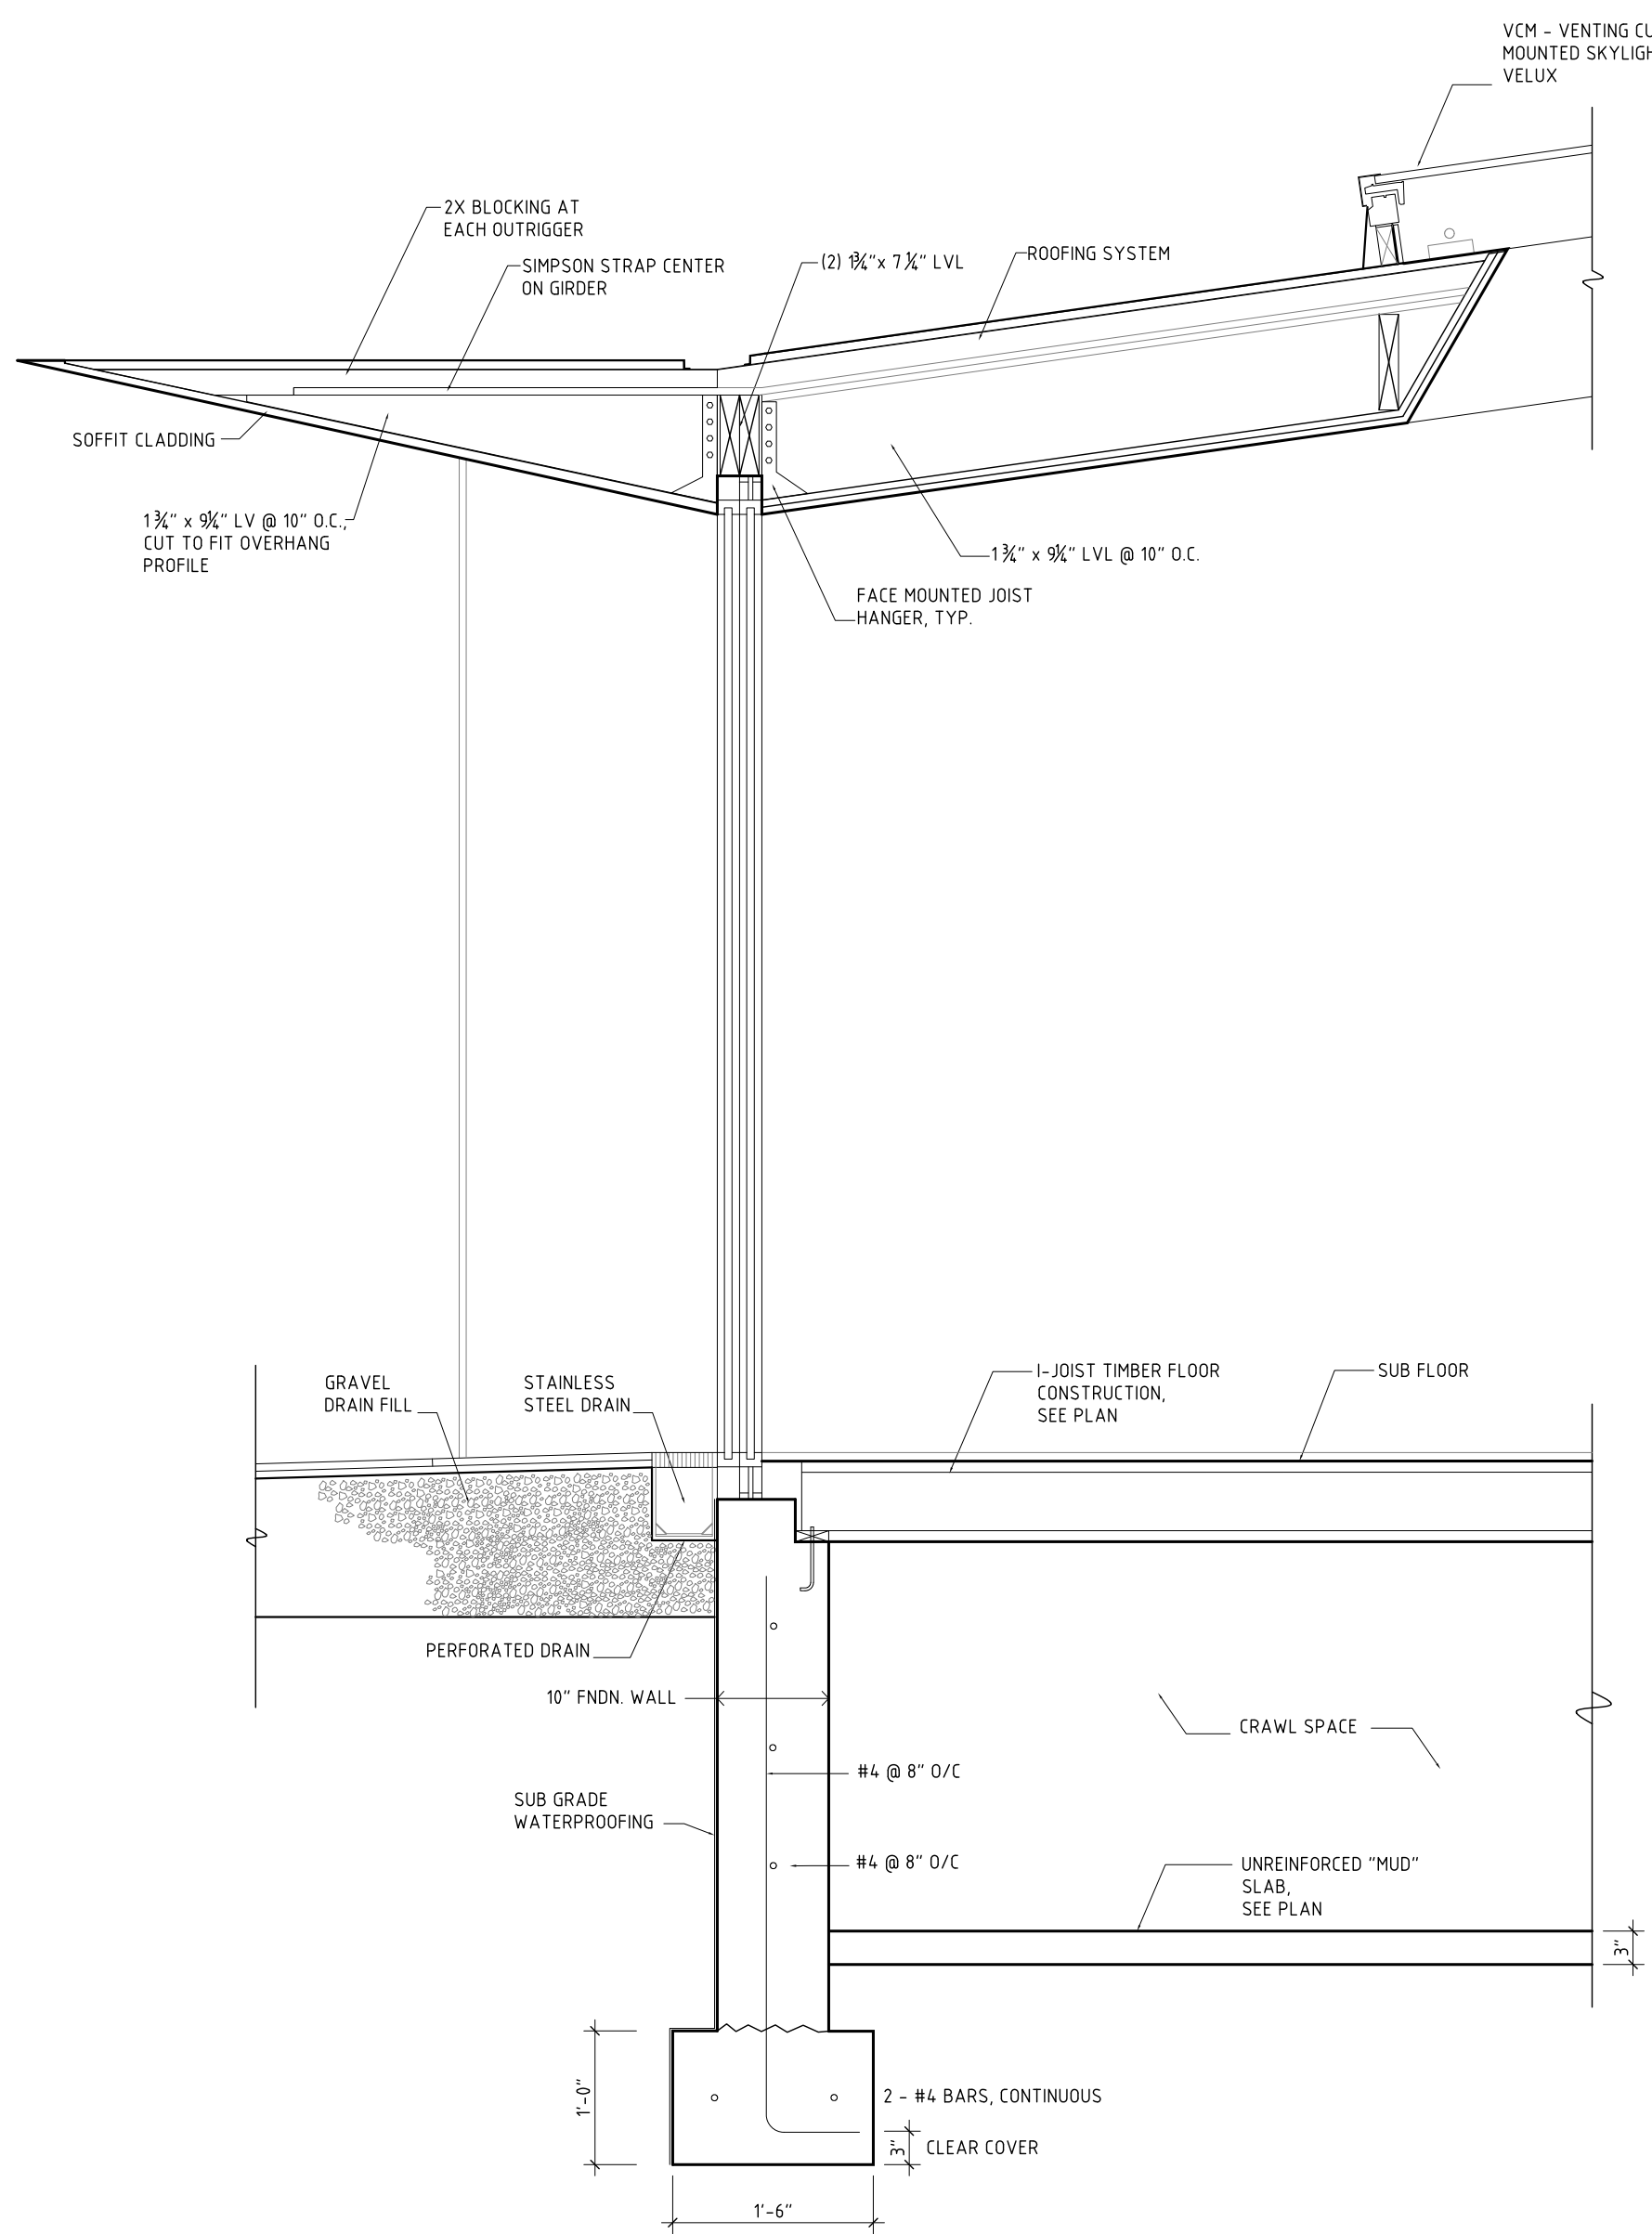


1 EXTERIOR WALL SECTION
3/4"=1'

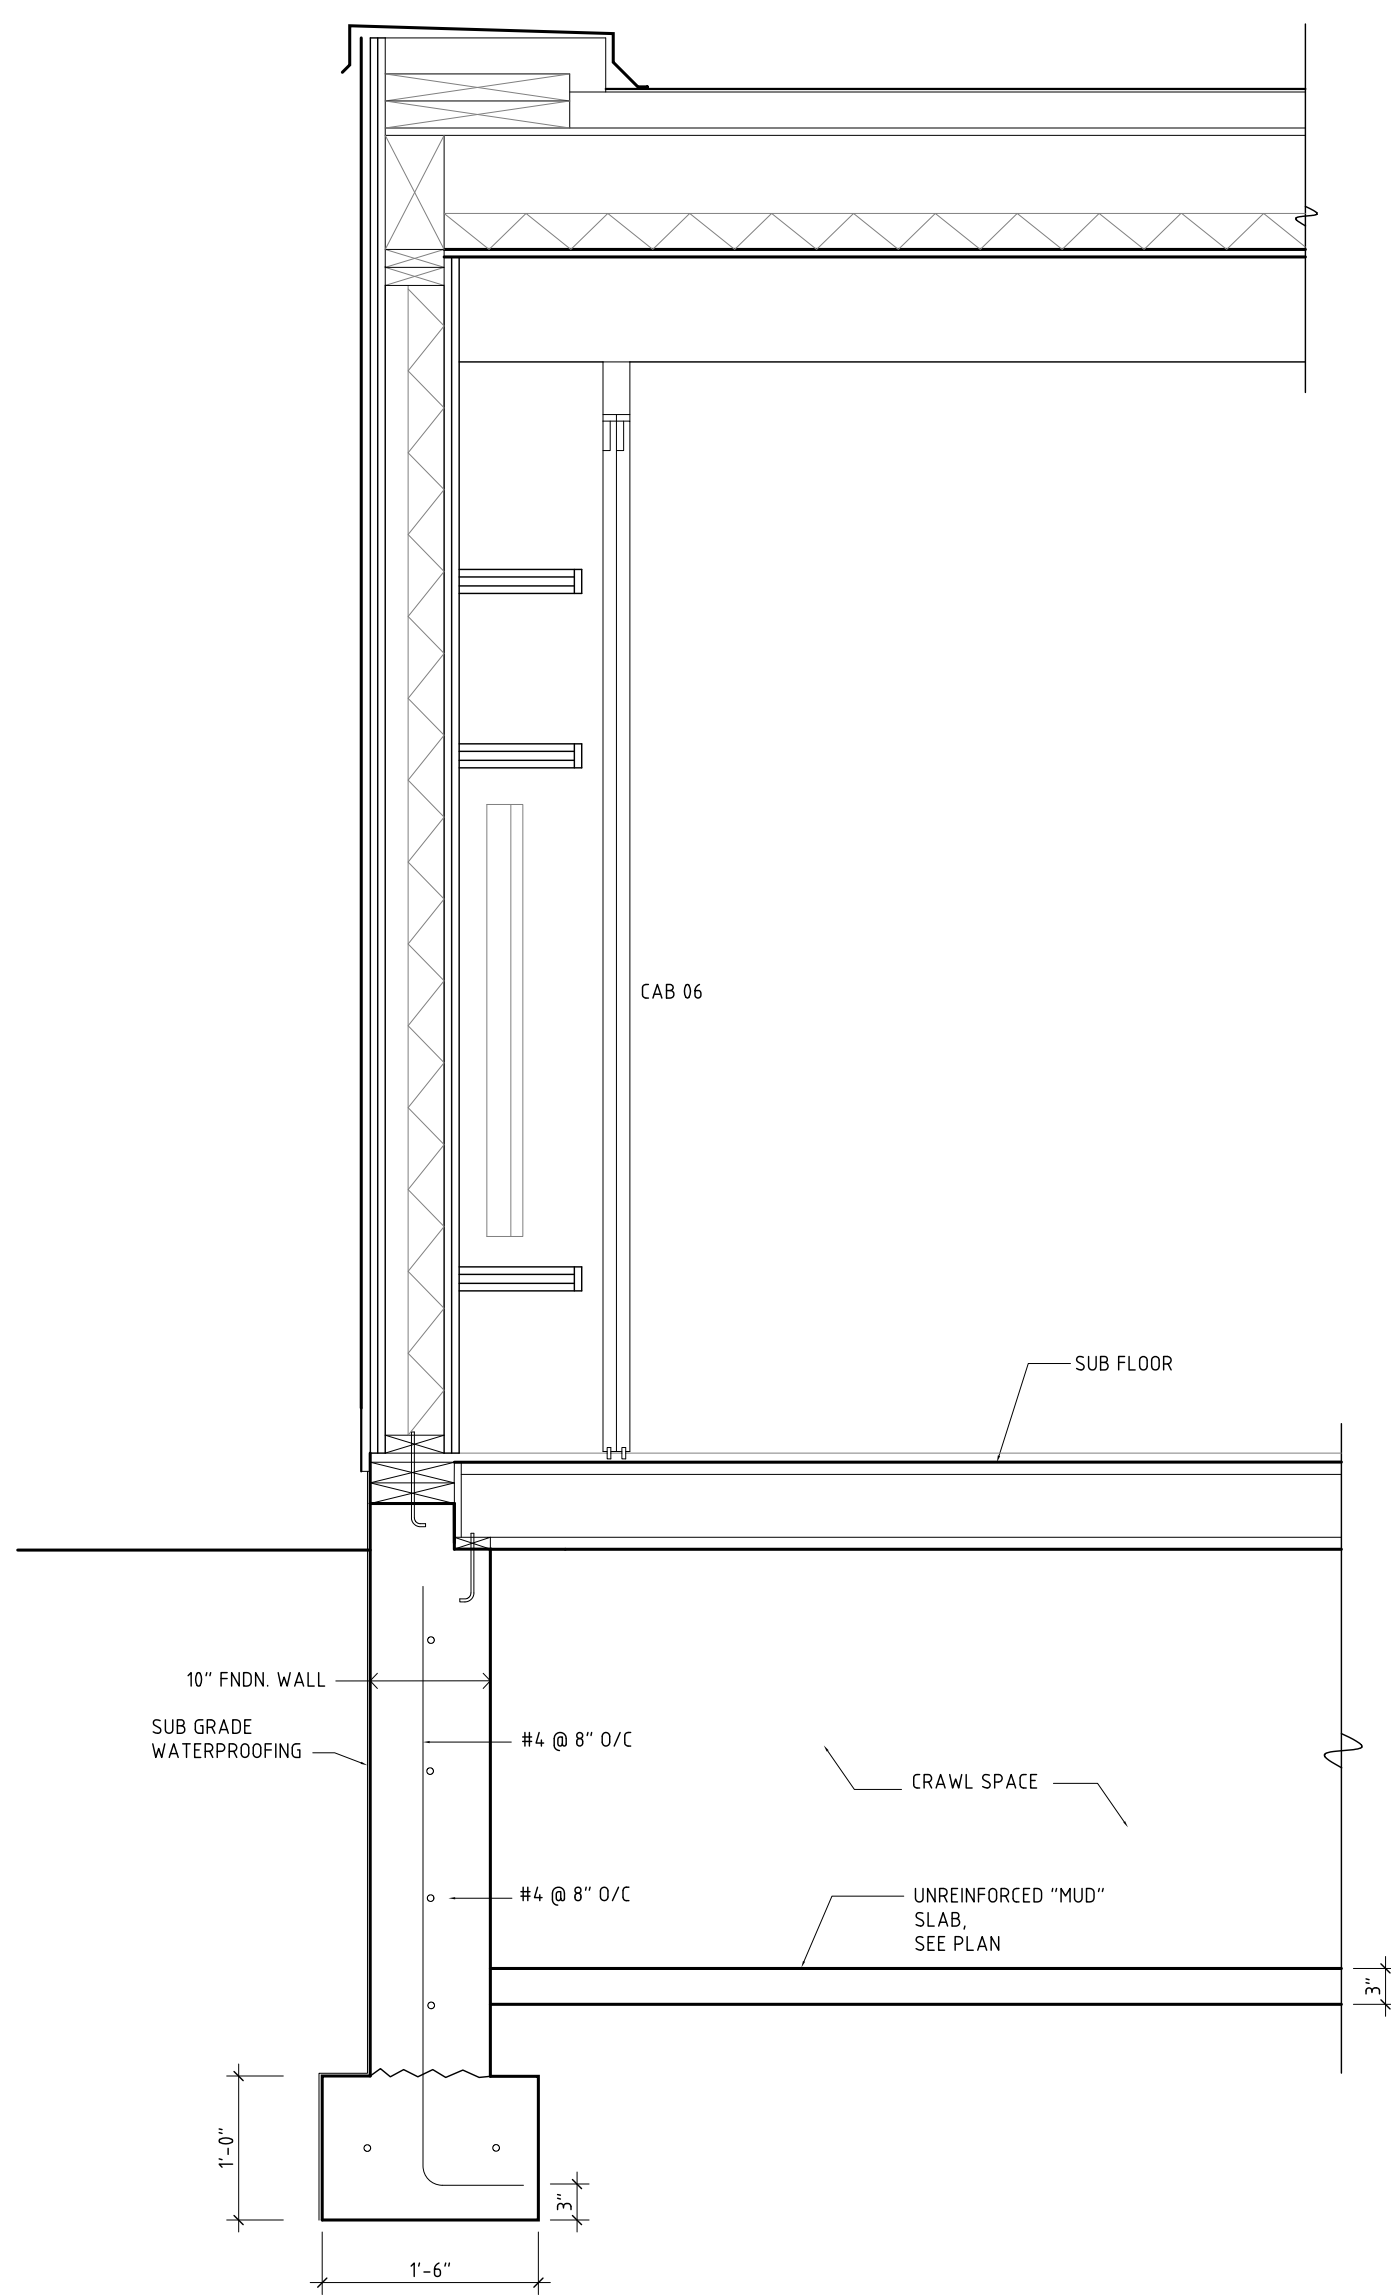

2 EXTERIOR WALL SECTION - STUD WALL
3/4"=1'

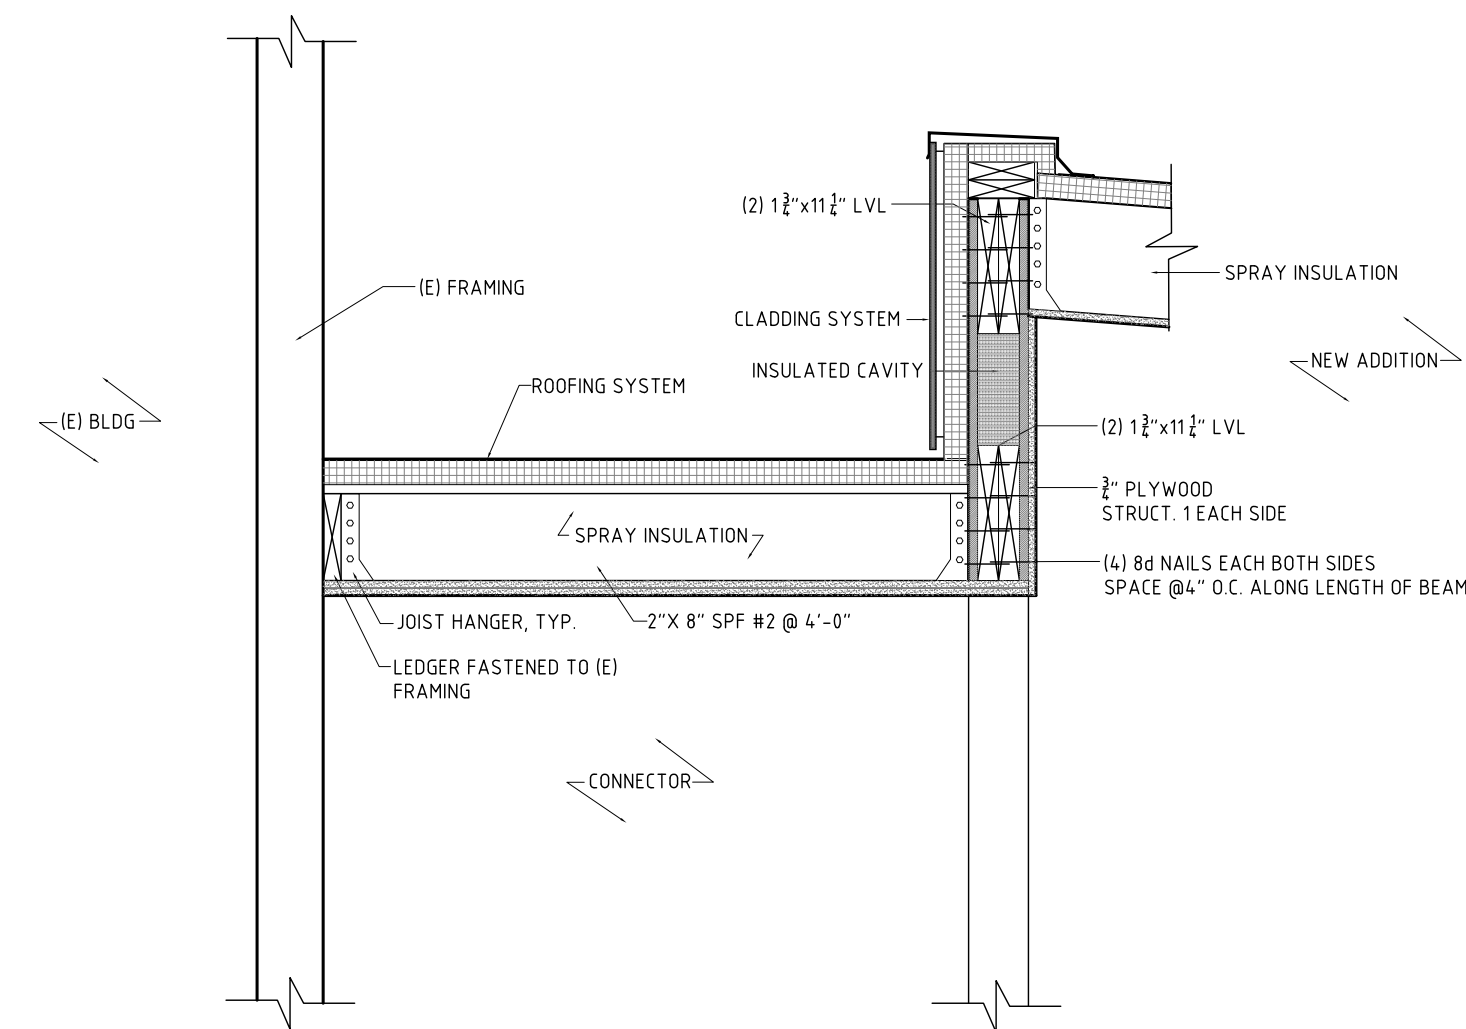

3 EXTERIOR WALL SECTION - BOX BEAM
3/4"=1'

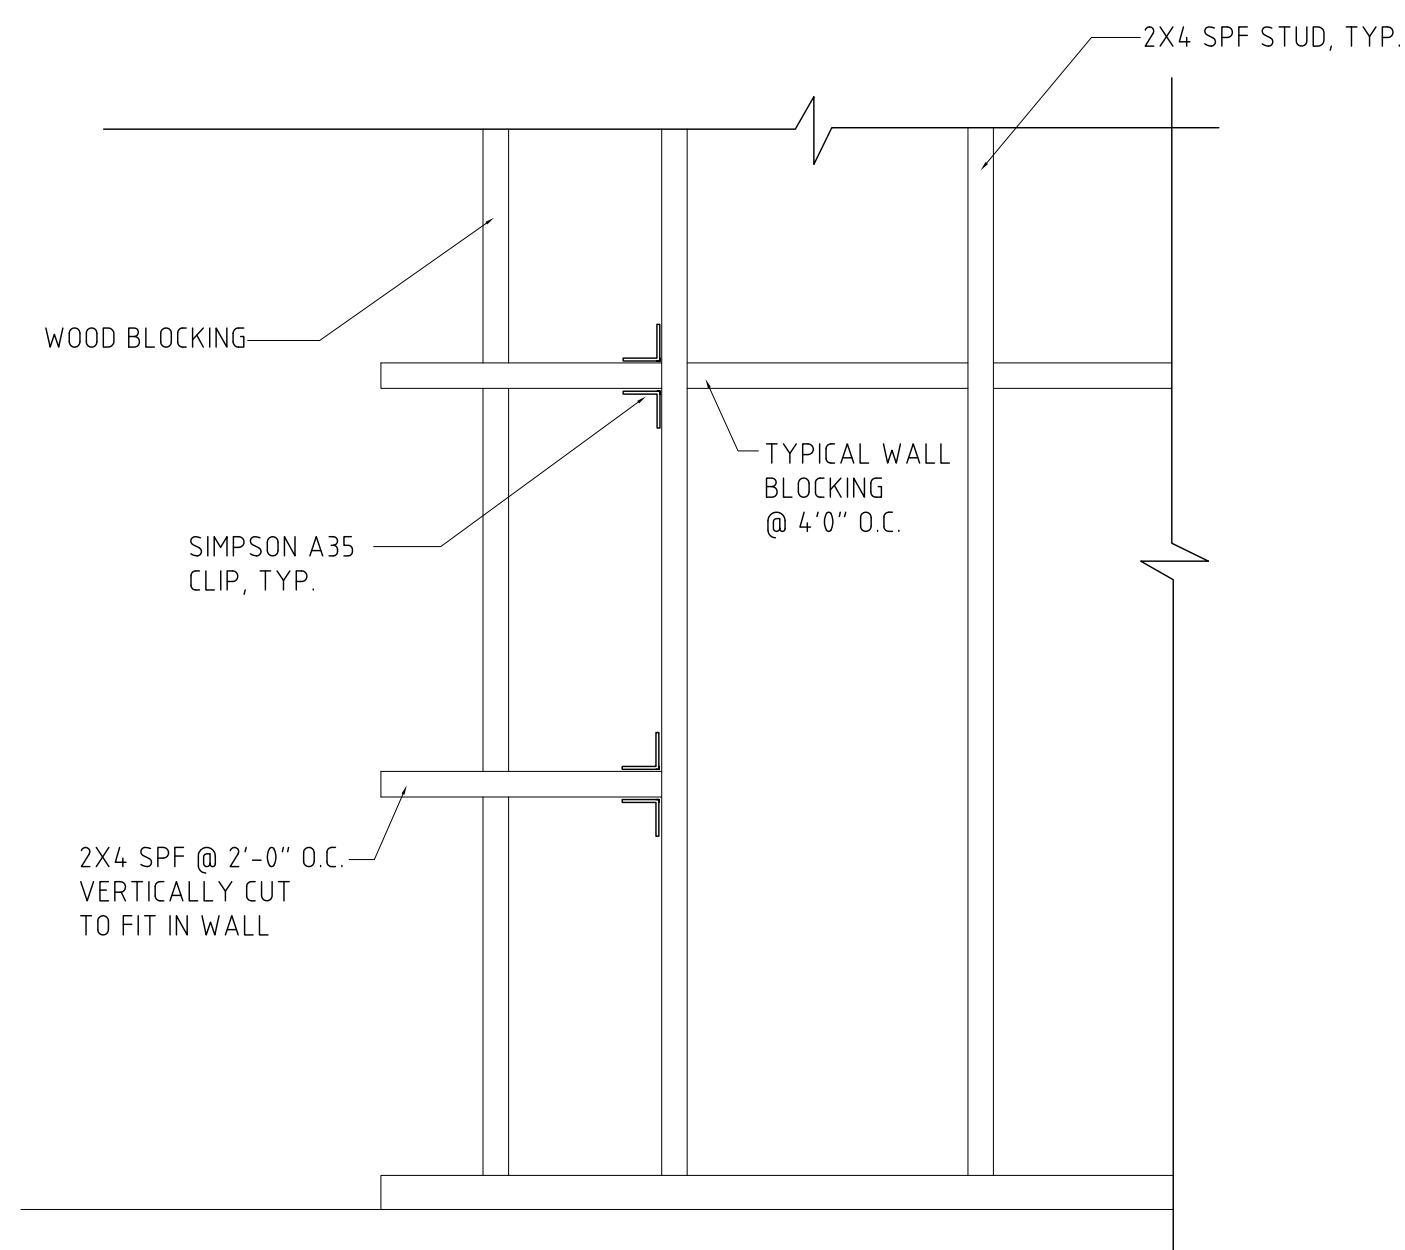

4 EXTERIOR WALL ELEVATION
3/4"=1'

S s D

171 BROOKLINE STREET
CAMBRIDGE, MA 02139

TEL: 617.576.9300

WWW.SSDARCHITECTURE.COM
INFO@SSDARCHITECTURE.COM

CONSULTANTS:

STRUCTURAL ENGINEER:
SIMPSON STRAP & HANGER
41 SEVEN STREET
WALTHAM, MA 02453

MA 781.907.9000
FAC 781.907.9009
WWW.SPH.COM

SURVEYOR:
AGI ENGINEERING
166 WATER STREET
STOUGHTON, MA

PROJECT:

Travers-Smith Residence

PROJECT ADDRESS:

119 PARK AVENUE
ARLINGTON, MA 02476

DWG TITLE:

EXTERIOR WALL
SECTION

SEAL & SIGNATURE:

DATE:

11 JUNE 2019

PROJECT No.:

1012

DWG BY:

WWW.BB.CC.LP.SC.JC.EV.TH

DWG BY:


JH

DWG NO.:

A-401

DOB ID No.:

PAGE No.:

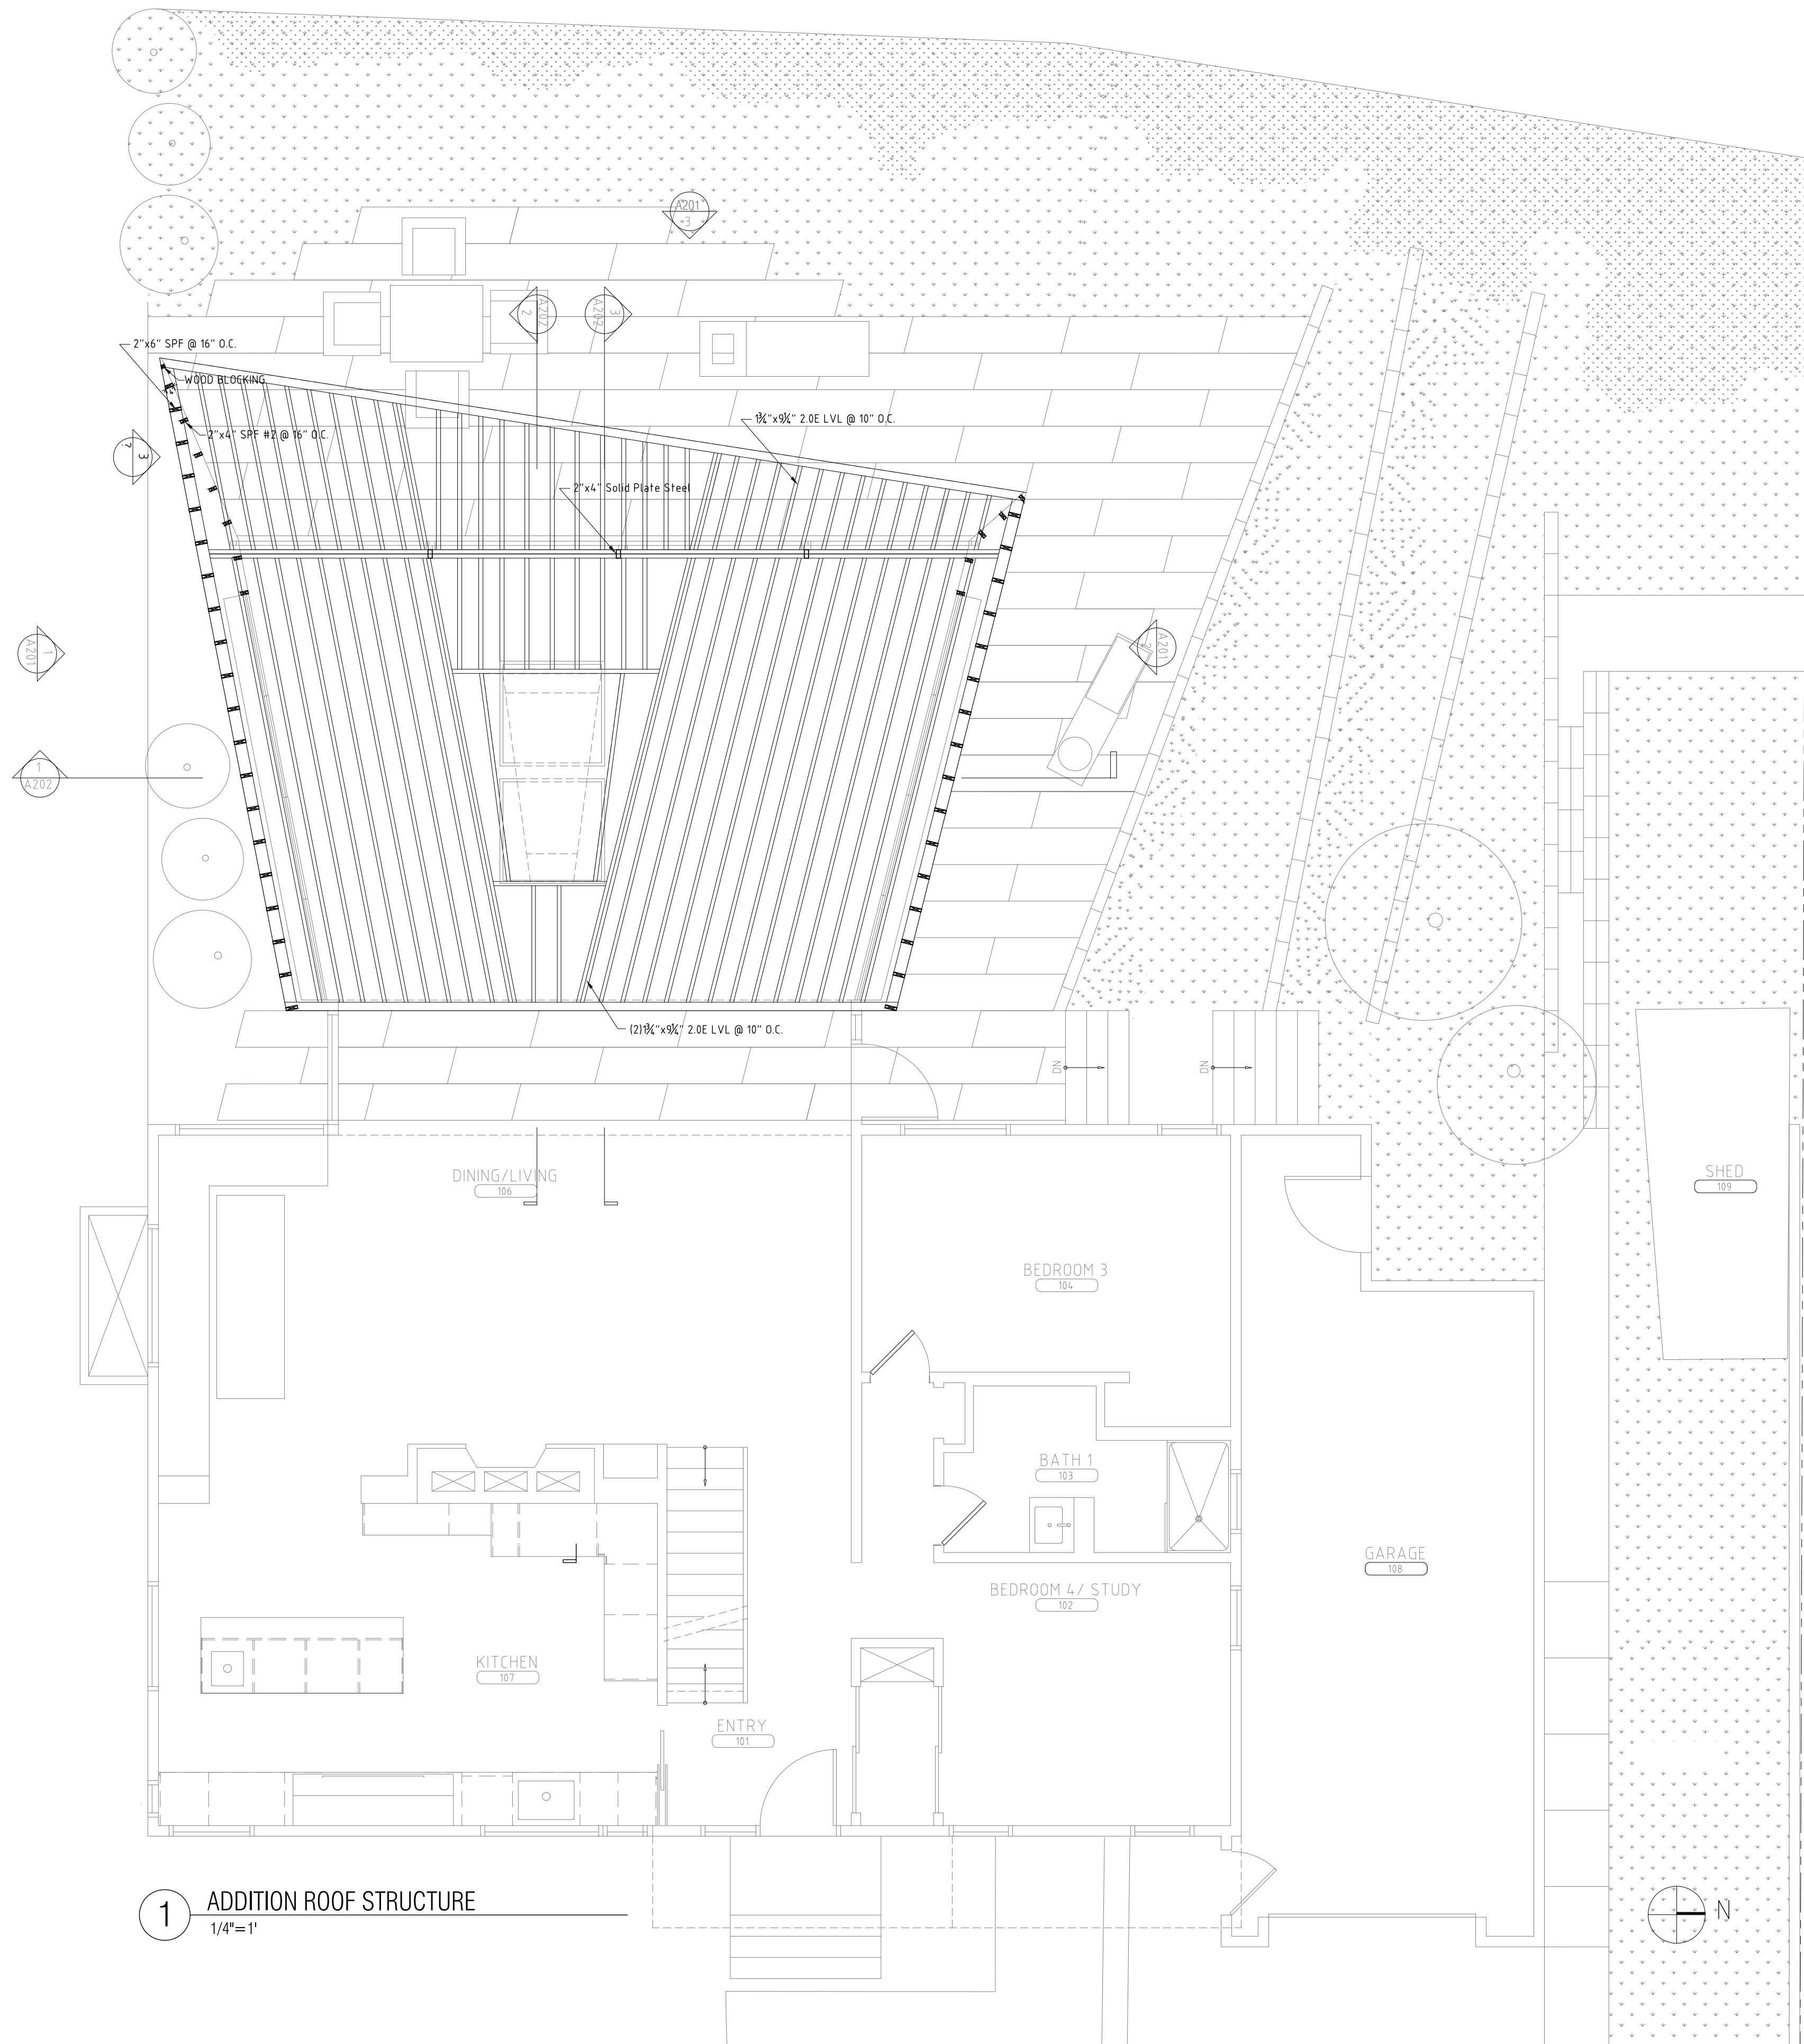

1 ADDITION ROOF STRUCTURE
1/4"=1'

S s D
171 BROOKLINE STREET
CAMBRIDGE, MA 02139
tel: 617. 576. 9300
www.ssdarchitecture.com
info@ssdarchitecture.com

CONSULTANTS:
STRUCTURAL ENGINEER:
SIMPSON CLARK & WESSER
41 SEVEN STREET
BUILDING 1, SUITE 200
WALTHAM, MA 02453
MA 781.907.9000
tc: 781.907.9009
www.sclw.com

SURVEYOR:
AGI ENGINEERING
156 WATER STREET
STOUGHTON, MA

PROJECT:
Travers-Smith Residence

PROJECT ADDRESS:
119 PARK AVENUE
ARLINGTON, MA 02476

DWG TITLE:

STRUCTURE

SEAL & SIGNATURE:

DATE: 11 JUNE 2019
PROJECT No.: 1012
DWG BY: WW,BB,CC,LM,SC,JC,EV,TH
CHK BY: JH
DWG No.: S-101

DOB ID No.:

PAGE No.: